





SFO

San Francisco International Airport

Key Map

NO.	DATE	REVISIONS
1	06/29/2025	ISSUE FOR PERMIT
2	11/14/2025	DESIGN CHANGES
3	02/20/2026	DESIGN CHANGES 2

Turner

100 Pringle Ave, Suite 340
Walnut Creek, CA 94596
415-509-4229

Gensler

220 Montgomery Street, Suite 200
San Francisco, CA 94104
415-433-3700

TEF

1420 Sutter Street
San Francisco, CA 94109
415-391-7918

10071.76_400

TERMINAL 3 WEST
MODERNIZATION

PACKAGE 6 - VOL 1

REFLECTED CEILING PLAN -
DEPARTURES LEVEL 2 - AREA
10

APPROVED:

APPROVED:

DESIGNED BY:

CHECKED BY:

DRAWN BY:

DATE:

SCALE:

1/8" = 1'-0"

SHEET NUMBER

06-A3.L2.10

21/02/2025 2:54:56 PM

3003 LIGHT FIXTURE, TYP. SED

5502 CANOPY METAL SOFFIT PANEL, TYP.

7023 SUSPENDED DOOR NUMBER SIGNAGE, PROVIDE POWER AND DATA, SEE SIGNAGE DRAWINGS.

7024 SUSPENDED DIRECTIONAL SIGNAGE, SEE SIGNAGE DRAWINGS.

GENERAL NOTES

1. WHERE NO CEILING FINISH IS CALLED OUT ON THE RCP, NO CEILING FINISH IS REQUIRED, U.N.O.

2. SEE ELECTRICAL DRAWINGS FOR LIGHT FIXTURE SCHEDULE, EXIT LIGHTS AND OTHER LIFE SAFETY DEVICES.

3. SEE MEP DRAWINGS FOR DESIGN OF MECHANICAL AND ELECTRICAL SYSTEMS. ARCHITECTURAL PLANS GOVERN FOR LOCATION OF ITEMS INSTALLED IN CEILINGS. NOTIFY ARCHITECT IF CONFLICTS OCCUR.

4. INSTALL REGISTERS AND LIGHT FIXTURES WITHIN GRID LINES. INSTALL SPEAKERS, LIGHT FIXTURES, AND OTHER CEILING ELEMENTS IN THE GEOMETRIC CENTER OF ACOUSTICAL UNITS OR CEILING PANELS, U.N.O.

5. ARRANGE ABOVE THE CEILING ITEMS TO PROVIDE ADEQUATE CLEARANCES FOR CEILING AND ITS DEVICES.

6. VERIFY ACCESS PANEL LOCATIONS WITH ARCHITECT PRIOR TO LAYOUT OF WORK REQUIRING ACCESS.

7. PLUMB ALL STEM, AIRCRAFT CABLE, AND APPURTENANCES USED TO SUPPORT SUSPENDED LIGHT FIXTURES, U.N.O.

8. LOCATE ALL HEADS TO ALIGN WITH LIGHT FIXTURES, U.N.O.

9. PROVIDE SPRINKLER HEAD LOCATIONS FOR ARCHITECT'S REVIEW PRIOR TO ANY INSTALLATION. IF IT IS NOT POSSIBLE TO LOCATE HEADS AS REQUIRED FOR ANY REASON, INCLUDING, CODE REQUIREMENTS, DO NOT PROCEED WITH WORK UNTIL SUCH CONDITIONS HAVE BEEN REVIEWED WITH ARCHITECT.

10. PROVIDE CONCEALED SPRINKLER HEADS WITH CAPS WHICH ARE FACTORY-PAINTED TO MATCH THE CEILING IN DRYWALL AND ACT CEILINGS.

11. NO COMBUSTIBLE MATERIALS ALLOWED IN CEILING PLENUM.

12. G.C. TO CONFIRM WITH ARCHITECT ON ALL SPEAKER LOCATIONS PRIOR TO INSTALLATION.

13. PAINT ALL SURFACES BLACK THAT ARE VISIBLE THROUGH RETURN AIR GRILLES OR CEILING OPENINGS GREATER THAN 3".


14. SEE FINISH SCHEDULE FOR CEILING FINISHES.

15. SEE SHEET A9 SERIES FOR TYPICAL CEILING DETAILS.

16. ALL AREAS TO BE SPRINKLERED PER NFPA 13. REFER TO FIRE PROTECTION DRAWINGS FOR ABOVE-CEILING SPRINKLER COVERAGE.


17. ALL MECHANICAL DUCT PENETRATIONS THROUGH RATED ASSEMBLIES TO HAVE FIRE SMOKE DAMPER, TYP.

18. CEILING HEIGHTS AND SPOT ELEVATIONS, INCLUDING CEILINGS AT RESTROOMS WITH DEPRESSIONED SLABS, ARE MEASURED FROM TOC OF THE PRIMARY LEVEL INDICATED BY THE SHEET SERIES, U.N.O.: (FROM NAVD88 0+01.81 = 2'-10" L1 = 11'-2", L2 = 27'-2", L3 = 42'-9", R2 = 41'-2", R3 = 41'-2", R4 = 41'-2", R5 = 41'-2", R6 = 41'-2", R7 = 41'-2", R8 = 41'-2", R9 = 41'-2", R10 = 41'-2", R11 = 41'-2", R12 = 41'-2", R13 = 41'-2", R14 = 41'-2", R15 = 41'-2", R16 = 41'-2", R17 = 41'-2", R18 = 41'-2", R19 = 41'-2", R20 = 41'-2", R21 = 41'-2", R22 = 41'-2", R23 = 41'-2", R24 = 41'-2", R25 = 41'-2", R26 = 41'-2", R27 = 41'-2", R28 = 41'-2", R29 = 41'-2", R30 = 41'-2", R31 = 41'-2", R32 = 41'-2", R33 = 41'-2", R34 = 41'-2", R35 = 41'-2", R36 = 41'-2", R37 = 41'-2", R38 = 41'-2", R39 = 41'-2", R40 = 41'-2", R41 = 41'-2", R42 = 41'-2", R43 = 41'-2", R44 = 41'-2", R45 = 41'-2", R46 = 41'-2", R47 = 41'-2", R48 = 41'-2", R49 = 41'-2", R50 = 41'-2", R51 = 41'-2", R52 = 41'-2", R53 = 41'-2", R54 = 41'-2", R55 = 41'-2", R56 = 41'-2", R57 = 41'-2", R58 = 41'-2", R59 = 41'-2", R60 = 41'-2", R61 = 41'-2", R62 = 41'-2", R63 = 41'-2", R64 = 41'-2", R65 = 41'-2", R66 = 41'-2", R67 = 41'-2", R68 = 41'-2", R69 = 41'-2", R70 = 41'-2", R71 = 41'-2", R72 = 41'-2", R73 = 41'-2", R74 = 41'-2", R75 = 41'-2", R76 = 41'-2", R77 = 41'-2", R78 = 41'-2", R79 = 41'-2", R80 = 41'-2", R81 = 41'-2", R82 = 41'-2", R83 = 41'-2", R84 = 41'-2", R85 = 41'-2", R86 = 41'-2", R87 = 41'-2", R88 = 41'-2", R89 = 41'-2", R90 = 41'-2", R91 = 41'-2", R92 = 41'-2", R93 = 41'-2", R94 = 41'-2", R95 = 41'-2", R96 = 41'-2", R97 = 41'-2", R98 = 41'-2", R99 = 41'-2", R100 = 41'-2", R101 = 41'-2", R102 = 41'-2", R103 = 41'-2", R104 = 41'-2", R105 = 41'-2", R106 = 41'-2", R107 = 41'-2", R108 = 41'-2", R109 = 41'-2", R110 = 41'-2", R111 = 41'-2", R112 = 41'-2", R113 = 41'-2", R114 = 41'-2", R115 = 41'-2", R116 = 41'-2", R117 = 41'-2", R118 = 41'-2", R119 = 41'-2", R120 = 41'-2", R121 = 41'-2", R122 = 41'-2", R123 = 41'-2", R124 = 41'-2", R125 = 41'-2", R126 = 41'-2", R127 = 41'-2", R128 = 41'-2", R129 = 41'-2", R130 = 41'-2", R131 = 41'-2", R132 = 41'-2", R133 = 41'-2", R134 = 41'-2", R135 = 41'-2", R136 = 41'-2", R137 = 41'-2", R138 = 41'-2", R139 = 41'-2", R140 = 41'-2", R141 = 41'-2", R142 = 41'-2", R143 = 41'-2", R144 = 41'-2", R145 = 41'-2", R146 = 41'-2", R147 = 41'-2", R148 = 41'-2", R149 = 41'-2", R150 = 41'-2", R151 = 41'-2", R152 = 41'-2", R153 = 41'-2", R154 = 41'-2", R155 = 41'-2", R156 = 41'-2", R157 = 41'-2", R158 = 41'-2", R159 = 41'-2", R160 = 41'-2", R161 = 41'-2", R162 = 41'-2", R163 = 41'-2", R164 = 41'-2", R165 = 41'-2", R166 = 41'-2", R167 = 41'-2", R168 = 41'-2", R169 = 41'-2", R170 = 41'-2", R171 = 41'-2", R172 = 41'-2", R173 = 41'-2", R174 = 41'-2", R175 = 41'-2", R176 = 41'-2", R177 = 41'-2", R178 = 41'-2", R179 = 41'-2", R180 = 41'-2", R181 = 41'-2", R182 = 41'-2", R183 = 41'-2", R184 = 41'-2", R185 = 41'-2", R186 = 41'-2", R187 = 41'-2", R188 = 41'-2", R189 = 41'-2", R190 = 41'-2", R191 = 41'-2", R192 = 41'-2", R193 = 41'-2", R194 = 41'-2", R195 = 41'-2", R196 = 41'-2", R197 = 41'-2", R198 = 41'-2", R199 = 41'-2", R200 = 41'-2", R201 = 41'-2", R202 = 41'-2", R203 = 41'-2", R204 = 41'-2", R205 = 41'-2", R206 = 41'-2", R207 = 41'-2", R208 = 41'-2", R209 = 41'-2", R210 = 41'-2", R211 = 41'-2", R212 = 41'-2", R213 = 41'-2", R214 = 41'-2", R215 = 41'-2", R216 = 41'-2", R217 = 41'-2", R218 = 41'-2", R219 = 41'-2", R220 = 41'-2", R221 = 41'-2", R222 = 41'-2", R223 = 41'-2", R224 = 41'-2", R225 = 41'-2", R226 = 41'-2", R227 = 41'-2", R228 = 41'-2", R229 = 41'-2", R230 = 41'-2", R231 = 41'-2", R232 = 41'-2", R233 = 41'-2", R234 = 41'-2", R235 = 41'-2", R236 = 41'-2", R237 = 41'-2", R238 = 41'-2", R239 = 41'-2", R240 = 41'-2", R241 = 41'-2", R242 = 41'-2", R243 = 41'-2", R244 = 41'-2", R245 = 41'-2", R246 = 41'-2", R247 = 41'-2", R248 = 41'-2", R249 = 41'-2", R250 = 41'-2", R251 = 41'-2", R252 = 41'-2", R253 = 41'-2", R254 = 41'-2", R255 = 41'-2", R256 = 41'-2", R257 = 41'-2", R258 = 41'-2", R259 = 41'-2", R260 = 41'-2", R261 = 41'-2", R262 = 41'-2", R263 = 41'-2", R264 = 41'-2", R265 = 41'-2", R266 = 41'-2", R267 = 41'-2", R268 = 41'-2", R269 = 41'-2", R270 = 41'-2", R271 = 41'-2", R272 = 41'-2", R273 = 41'-2", R274 = 41'-2", R275 = 41'-2", R276 = 41'-2", R277 = 41'-2", R278 = 41'-2", R279 = 41'-2", R280 = 41'-2", R281 = 41'-2", R282 = 41'-2", R283 = 41'-2", R284 = 41'-2", R285 = 41'-2", R286 = 41'-2", R287 = 41'-2", R288 = 41'-2", R289 = 41'-2", R290 = 41'-2", R291 = 41'-2", R292 = 41'-2", R293 = 41'-2", R294 = 41'-2", R295 = 41'-2", R296 = 41'-2", R297 = 41'-2", R298 = 41'-2", R299 = 41'-2", R300 = 41'-2", R301 = 41'-2", R302 = 41'-2", R303 = 41'-2", R304 = 41'-2", R305 = 41'-2", R306 = 41'-2", R307 = 41'-2", R308 = 41'-2", R309 = 41'-2", R310 = 41'-2", R311 = 41'-2", R312 = 41'-2", R313 = 41'-2", R314 = 41'-2", R315 = 41'-2", R316 = 41'-2", R317 = 41'-2", R318 = 41'-2", R319 = 41'-2", R320 = 41'-2", R321 = 41'-2", R322 = 41'-2", R323 = 41'-2", R324 = 41'-2", R325 = 41'-2", R326 = 41'-2", R327 = 41'-2", R328 = 41'-2", R329 = 41'-2", R330 = 41'-2", R331 = 41'-2", R332 = 41'-2", R333 = 41'-2", R334 = 41'-2", R335 = 41'-2", R336 = 41'-2", R337 = 41'-2", R338 = 41'-2", R339 = 41'-2", R340 = 41'-2", R341 = 41'-2", R342 = 41'-2", R343 = 41'-2", R344 = 41'-2", R345 = 41'-2", R346 = 41'-2", R347 = 41'-2", R348 = 41'-2", R349 = 41'-2", R350 = 41'-2", R351 = 41'-2", R352 = 41'-2", R353 = 41'-2", R354 = 41'-2", R355 = 41'-2", R356 = 41'-2", R357 = 41'-2", R358 = 41'-2", R359 = 41'-2", R360 = 41'-2", R361 = 41'-2", R362 = 41'-2", R363 = 41'-2", R364 = 41'-2", R365 = 41'-2", R366 = 41'-2", R367 = 41'-2", R368 = 41'-2", R369 = 41'-2", R370 = 41'-2", R371 = 41'-2", R372 = 41'-2", R373 = 41'-2", R374 = 41'-2", R375 = 41'-2", R376 = 41'-2", R377 = 41'-2", R378 = 41'-2", R379 = 41'-2", R380 = 41'-2", R381 = 41'-2", R382 = 41'-2", R383 = 41'-2", R384 = 41'-2", R385 = 41'-2", R386 = 41'-2", R387 = 41'-2", R388 = 41'-2", R389 = 41'-2", R390 = 41'-2", R391 = 41'-2", R392 = 41'-2", R393 = 41'-2", R394 = 41'-2", R395 = 41'-2", R396 = 41'-2", R397 = 41'-2", R398 = 41'-2", R399 = 41'-2", R400 = 41'-2", R401 = 41'-2", R402 = 41'-2", R403 = 41'-2", R404 = 41'-2", R405 = 41'-2", R406 = 41'-2", R407 = 41'-2", R408 = 41'-2", R409 = 41'-2", R410 = 41'-2", R411 = 41'-2", R412 = 41'-2", R413 = 41'-2", R414 = 41'-2", R415 = 41'-2", R416 = 41'-2", R417 = 41'-2", R418 = 41'-2", R419 = 41'-2", R420 = 41'-2", R421 = 41'-2", R422 = 41'-2", R423 = 41'-2", R424 = 41'-2", R425 = 41'-2", R426 = 41'-2", R427 = 41'-2", R428 = 41'-2", R429 = 41'-2", R430 = 41'-2", R431 = 41'-2", R432 = 41'-2", R433 = 41'-2", R434 = 41'-2", R435 = 41'-2", R436 = 41'-2", R437 = 41'-2", R438 = 41'-2", R439 = 41'-2", R440 = 41'-2", R441 = 41'-2", R442 = 41'-2", R443 = 41'-2", R444 = 41'-2", R445 = 41'-2", R446 = 41'-2", R447 = 41'-2", R448 = 41'-2", R449 = 41'-2", R450 = 41'-2", R451 = 41'-2", R452 = 41'-2", R453 = 41'-2", R454 = 41'-2", R455 = 41'-2", R456 = 41'-2", R457 = 41'-2", R458 = 41'-2", R459 = 41'-2", R460 = 41'-2", R461 = 41'-2", R462 = 41'-2", R463 = 41'-2", R464 = 41'-2", R465 = 41'-2", R466 = 41'-2", R467 = 41'-2", R468 = 41'-2", R469 = 41'-2", R470 = 41'-2", R471 = 41'-2", R472 = 41'-2", R473 = 41'-2", R474 = 41'-2", R475 = 41'-2", R476 = 41'-2", R477 = 41'-2", R478 = 41'-2", R479 = 41'-2", R480 = 41'-2", R481 = 41'-2", R482 = 41'-2", R483 = 41'-2", R484 = 41'-2", R485 = 41'-2", R486 = 41'-2", R487 = 41'-2", R488 = 41'-2", R489 = 41'-2", R490 = 41'-2", R491 = 41'-2", R492 = 41'-2", R493 = 41'-2", R494 = 41'-2", R495 = 41'-2", R496 = 41'-2", R497 = 41'-2", R498 = 41'-2", R499 = 41'-2", R500 = 41'-2", R501 = 41'-2", R502 = 41'-2", R503 = 41'-2", R504 = 41'-2", R505 = 41'-2", R506 = 41'-2", R507 = 41'-2", R508 = 41'-2", R509 = 41'-2", R510 = 41'-2", R511 = 41'-2", R512 = 41'-2", R513 = 41'-2", R514 = 41'-2", R515 = 41'-2", R516 = 41'-2", R517 = 41'-2", R518 = 41'-2", R519 = 41'-2", R520 = 41'-2", R521 = 41'-2", R522 = 41'-2", R523 = 41'-2", R524 = 41'-2", R525 = 41'-2", R526 = 41'-2", R527 = 41'-2", R528 = 41'-2", R529 = 41'-2", R530 = 41'-2", R531 = 41'-2", R532 = 41'-2", R533 = 41'-2", R534 = 41'-2", R535 = 41'-2", R536 = 41'-2", R537 = 41'-2", R538 = 41'-2", R539 = 41'-2", R540 = 41'-2", R541 = 41'-2", R542 = 41'-2", R543 = 41'-2", R544 = 41'-2", R545 = 41'-2", R546 = 41'-2", R547 = 41'-2", R548 = 41'-2", R549 = 41'-2", R550 = 41'-2", R551 = 41'-2", R552 = 41'-2", R553 = 41'-2", R554 = 41'-2", R555 = 41'-2", R556 = 41'-2", R557 = 41'-2", R558 = 41'-2", R559 = 41'-2", R560 = 41'-2", R561 = 41'-2", R562 = 41'-2", R563 = 41'-2", R564 = 41'-2", R565 = 41'-2", R566 = 41'-2", R567 = 41'-2", R568 = 41'-2", R569 = 41'-2", R570 = 41'-2", R571 = 41'-2", R572 = 41'-2", R573 = 41'-2", R574 = 41'-2", R575 = 41'-2", R576 = 41'-2", R577 = 41'-2", R578 = 41'-2", R579 = 41'-2", R580 = 41'-2", R581 = 41'-2", R582 = 41'-2", R583 = 41'-2", R584 = 41'-2", R585 = 41'-2", R586 = 41'-2", R587 = 41'-2", R588 = 41'-2", R589 = 41'-2", R590 = 41'-2", R591 = 41'-2", R592 = 41'-2", R593 = 41'-2", R594 = 41'-2", R595 = 41'-2", R596 = 41'-2", R597 = 41'-2", R598 = 41'-2", R599 = 41'-2", R600 = 41'-2", R601 = 41'-2", R602 = 41'-2", R603 = 41'-2", R604 = 41'-2", R605 = 41'-2", R606 = 41'-2", R607 = 41'-2", R608 = 41'-2", R609 = 41'-2", R610 = 41'-2", R611 = 41'-2", R612 = 41'-2", R613 = 41'-2", R614 = 41'-2", R615 = 41'-2", R616 = 41'-2", R617 = 41'-2", R618 = 41'-2", R619 = 41'-2", R620 = 41'-2", R621 = 41'-2", R622 = 41'-2", R623 = 41'-2", R624 = 41'-2", R625 = 41'-2", R626 = 41'-2", R627 = 41'-2", R628 = 41'-2", R629 = 41'-2", R630 = 41'-2", R631 = 41'-2", R632 = 41'-2", R633 = 41'-2", R634 = 41'-2", R635 = 41'-2", R636 = 41'-2", R637 = 41'-2", R638 = 41'-2", R639 = 41'-2", R640 = 41'-2", R641 = 41'-2", R642 = 41'-2", R643 = 41'-2", R644 = 41'-2", R645 = 41'-2", R646 = 41'-2", R647 = 41'-2", R648 = 41'-2", R649 = 41'-2", R650 = 41'-2", R651 = 41'-2", R652 = 41'-2", R653 = 41'-2", R654 = 41'-2", R655 = 41'-2", R656 = 41'-2", R657 = 41'-2", R658 = 41'-2", R659 = 41'-2", R660 = 41'-2", R661 = 41'-2", R662 = 41'-2", R663 = 41'-2", R664 = 41'-2", R665 = 41'-2", R666 = 41'-2", R667 = 41'-2", R668 = 41'-2", R669 = 41'-2", R670 = 41'-2", R671 = 41'-2", R672 = 41'-2", R673 = 41'-2", R674 = 41'-2", R675 = 41'-2", R676 = 41'-2", R677 = 41'-2", R678 = 41'-2", R679 = 41'-2", R680 = 41'-2", R681 = 41'-2", R682 = 41'-2", R683 = 41'-2", R684 = 41'-2", R685 = 41'-2", R686 = 41'-2", R687 = 41'-2", R688 = 41'-2", R689 = 41'-2", R690 = 41'-2", R691 = 41'-2", R692 = 41'-2", R693 = 41'-2", R694 = 41'-2", R695 = 41'-2", R696 = 41'-2", R697 = 41'-2", R698 = 41'-2", R699 = 41'-2", R700 = 41'-2", R701 = 41'-2", R702 = 41'-2", R703 = 41'-2", R704 = 41'-2", R705 = 41'-2", R706 = 41'-2", R707 = 41'-2", R708 = 41'-2", R709 = 41'-2", R710 = 41'-2", R711 = 41'-2", R712 = 41'-2", R713 = 41'-2", R714 = 41'-2", R715 = 41'-2", R716 = 41'-2", R717 = 41'-2", R718 = 41'-2", R719 = 41'-2", R720 = 41'-2", R721 = 41'-2", R722 = 41'-2", R723 = 41'-2", R724 = 41'-2", R725 = 41'-2", R726 = 41'-2", R727 = 41'-2", R728 = 41'-2", R729 = 41'-2", R730 = 41'-2", R731 = 41'-2", R732 = 41'-2", R733 = 41'-2", R734 = 41'-2", R735 = 41'-2", R736 = 41'-2", R737 = 41'-2", R738 = 41'-2", R739 = 41'-2", R740 = 41'-2", R741 = 41'-2", R742 = 41'-2", R743 = 41'-2", R744 = 41'-2", R745 = 41'-2", R746 = 41'-2", R747 = 41'-2", R748 = 41'-2", R749 = 41'-2", R750 = 41'-2", R751 = 41'-2", R752 = 41'-2", R753 = 41'-2", R754 = 41'-2", R755 = 41'-2", R756 = 41'-2", R757 = 41'-2", R758 = 41'-2", R759 = 41'-2", R760 = 41'-2", R761 = 41'-2", R762 = 41'-2", R763 = 41'-2", R764 = 41'-2", R765 = 41'-2", R766 = 41'-2", R767 = 41'-2", R768 = 41'-2", R769 = 41'-2", R770 = 41'-2", R771 = 41'-2", R772 = 41'-2", R773 = 41'-2", R774 = 41'-2", R775 = 41'-2", R776 = 41'-2", R777 = 41'-2", R778 = 41'-2", R779 = 41'-2", R780 = 41'-2", R781 = 41'-2", R782 = 41'-2", R783 = 41'-2", R784 = 41'-2", R785 = 41'-2", R786 = 41'-2", R787 = 41'-2", R788 = 41'-2", R789 = 41'-2", R790 = 41'-2", R791 = 41'-2", R792 = 41'-2", R793 = 41'-2", R794 = 41'-2", R795 = 41'-2", R796 = 41'-2", R797 = 41'-2", R798 = 41'-2", R799 = 41'-2", R800 = 41'-2", R801 = 41'-2", R802 = 41'-2", R803 = 41'-2", R804 = 41'-2", R805 = 41'-2", R806 = 41'-2", R807 = 41'-2", R808 = 41'-2", R809 = 41'-2", R810 = 41'-2", R811 = 41'-2", R812 = 41'-2", R813 = 41'-2", R814 = 41'-2", R815 = 41'-2", R816 = 41'-2", R817 = 41'-2", R818 = 41'-2", R819 = 41'-2", R820 = 41'-2", R821 = 41'-2", R822 = 41'-2", R823 = 41'-2", R824 = 41'-2", R825 = 41'-2", R826 = 41'-2", R827 = 41'-2", R828 = 41'-2", R829 = 41'-2", R830 = 41'-2", R831 = 41'-2", R832 = 41'-2", R833 = 41'-2", R834 = 41'-2", R835 = 41'-2", R836 = 41'-2", R837 = 41'-2", R838 = 41'-2", R839 = 41'-2", R840 = 41'-2", R841 = 41'-2", R842 = 41'-2", R843 = 41'-2", R844 = 41'-2", R845 = 41'-2", R846 = 41'-2", R847 = 41'-2", R848 = 41'-2", R849 = 41'-2", R850 = 41'-2", R851 = 41'-2", R852 = 41'-2", R853 = 41'-2", R854 = 41'-2", R855 = 41'-2", R856 = 41'-2", R857 = 41'-2", R858 = 41'-2", R859 = 41'-2", R860 = 41'-2", R861 = 41'-2", R862 = 41'-2", R863 = 41'-2", R864 = 41'-2", R865 = 41'-2", R866 = 41'-2", R867 = 41'-2", R868 = 41'-2", R869 = 41'-2", R870 = 41'-2", R871 = 41'-2", R872 = 41'-2", R873 = 41'-2", R874 = 41'-2", R875 = 41'-2", R876 = 41'-2", R877 = 41'-2", R878 = 41'-2", R879 = 41'-2", R880 = 41'-2", R881 = 41'-2", R882 = 41'-2", R883 = 41'-2", R884 = 41'-2", R885 = 41'-2", R886 = 41'-2", R887 = 41'-2", R888 = 41'-2", R889 = 41'-2", R890 = 41'-2", R891 = 41'-2", R892 = 41'-2", R893 = 41'-2", R894 = 41'-2", R895 = 41'-2", R896 = 41'-2", R897 = 41'-2", R898 = 41'-2", R899 = 41'-2", R900 = 41'-2", R901 = 41'-2", R902 = 41'-2", R903 = 41'-2", R904 = 41'-2", R905 = 41'-2", R906 = 41'-2", R907 = 41'-2", R908 = 41'-2", R909 = 41'-2", R910 = 41'-2", R911 = 41'-2", R912 = 41'-2", R913 = 41'-2", R914 = 41'-2", R915 = 41'-2", R916 = 41'-2", R917 = 41'-2", R918 = 41'-2", R919 = 41'-2", R920 = 41'-2", R921 = 41'-2", R922 = 41'-2", R923 = 41'-2", R924 = 41'-2", R925 = 41'-2", R926 = 41'-2", R927 = 41'-2", R928 = 41'-2", R929 = 41'-2", R930 = 41'-2", R931 = 41'-2", R932 = 41'-2", R933 = 41'-2", R934 = 41'-2", R935 = 41'-2", R936 = 41'-2", R937 = 41'-2", R938 = 41'-2", R939 = 41'-2", R940 = 41'-2", R941 = 41'-2", R942 = 41'-2", R943 = 41'-2", R944 = 41'-2", R945 = 41'-2", R946 = 41'-2", R947 = 41'-2", R948 = 41'-2", R949 = 41'-2", R950 = 41'-2", R951 = 41'-2", R952 = 41'-2", R953 = 41'-2", R954 = 41'-2", R955 = 41'-2", R956 = 41'-2", R957 = 41'-2", R958 = 41'-2", R959 = 41'-2", R960 = 41'-2", R961 = 41'-2", R962 = 41'-2", R963 = 41'-2", R964 = 41'-2", R965 = 41'-2", R966 = 41'-2", R967 = 41'-2", R968 = 41'-2", R969 = 41'-2", R970 = 41'-2", R971 = 41'-2", R972 = 41'-2", R973 = 41'-2", R974 = 41'-2", R975 = 41'-2", R976 = 41'-2", R977 = 41'-2", R978 = 41'-2", R979 = 41'-2", R980 = 41'-2", R981 = 41'-2", R982 = 41'-2", R983 = 41'-2", R984 = 41'-2", R985 = 41'-2", R986 = 41'-2", R987 = 41'-2", R988 = 41'-2", R989 = 41'-2", R990 = 41'-2", R991 = 41'-2", R99

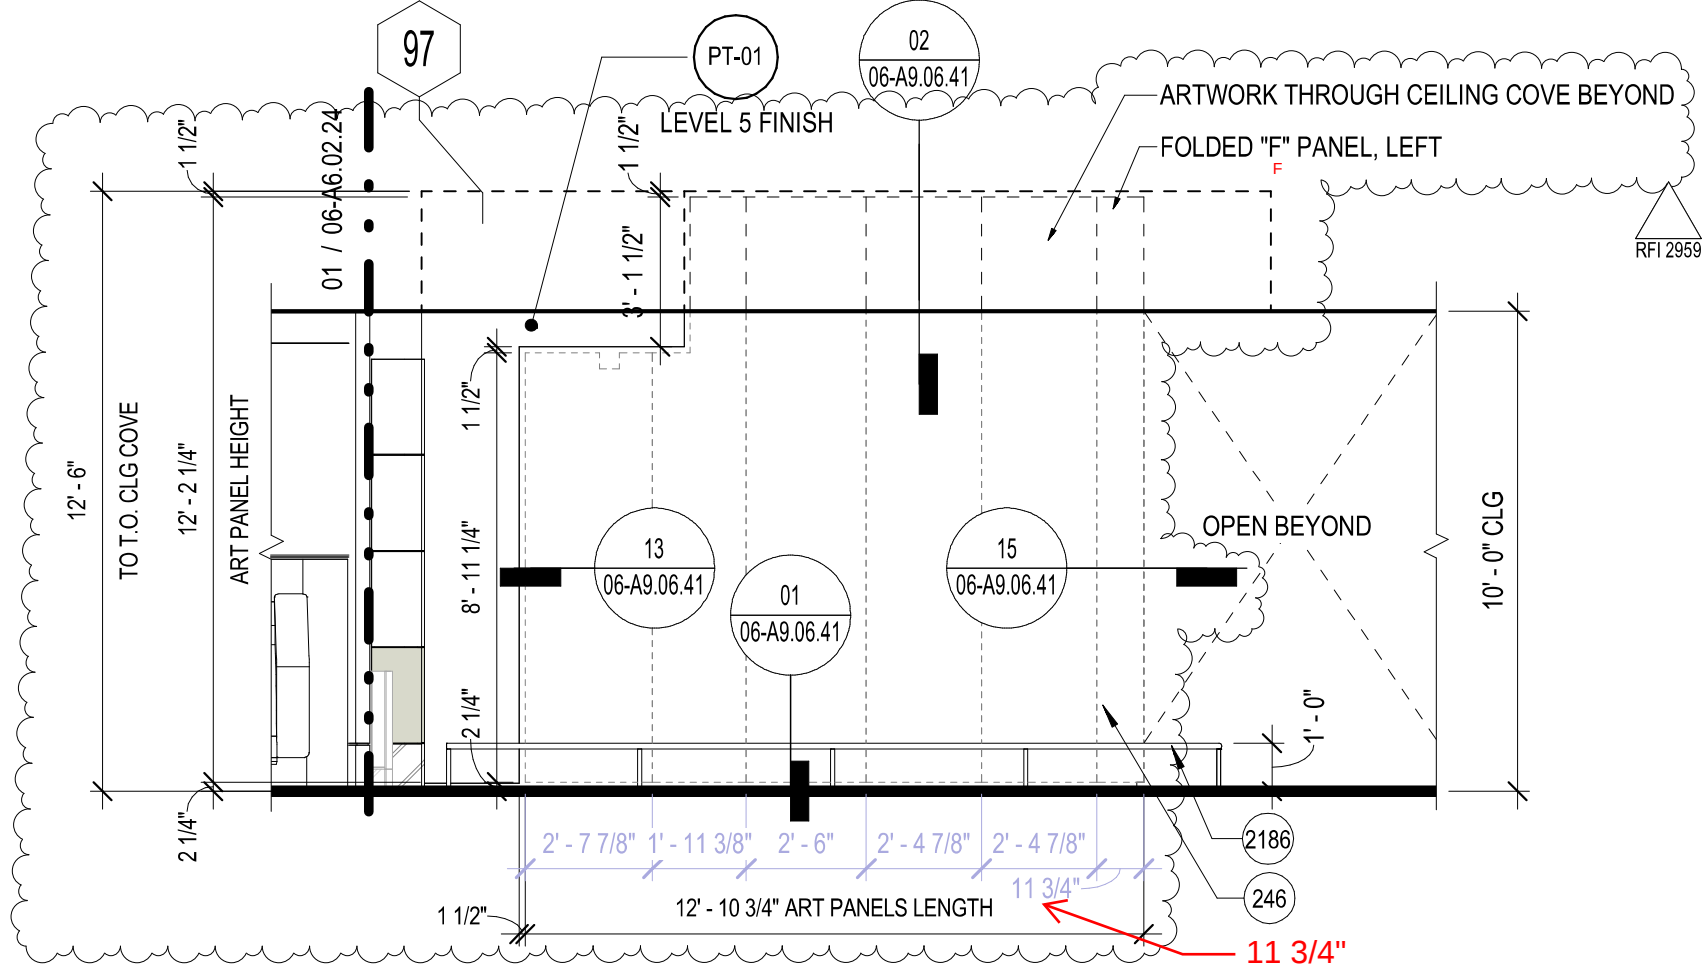

09 ELEV - 02 - 10 - ART WALL - BERLANT

SCALE: 1/4" = 1'-0"

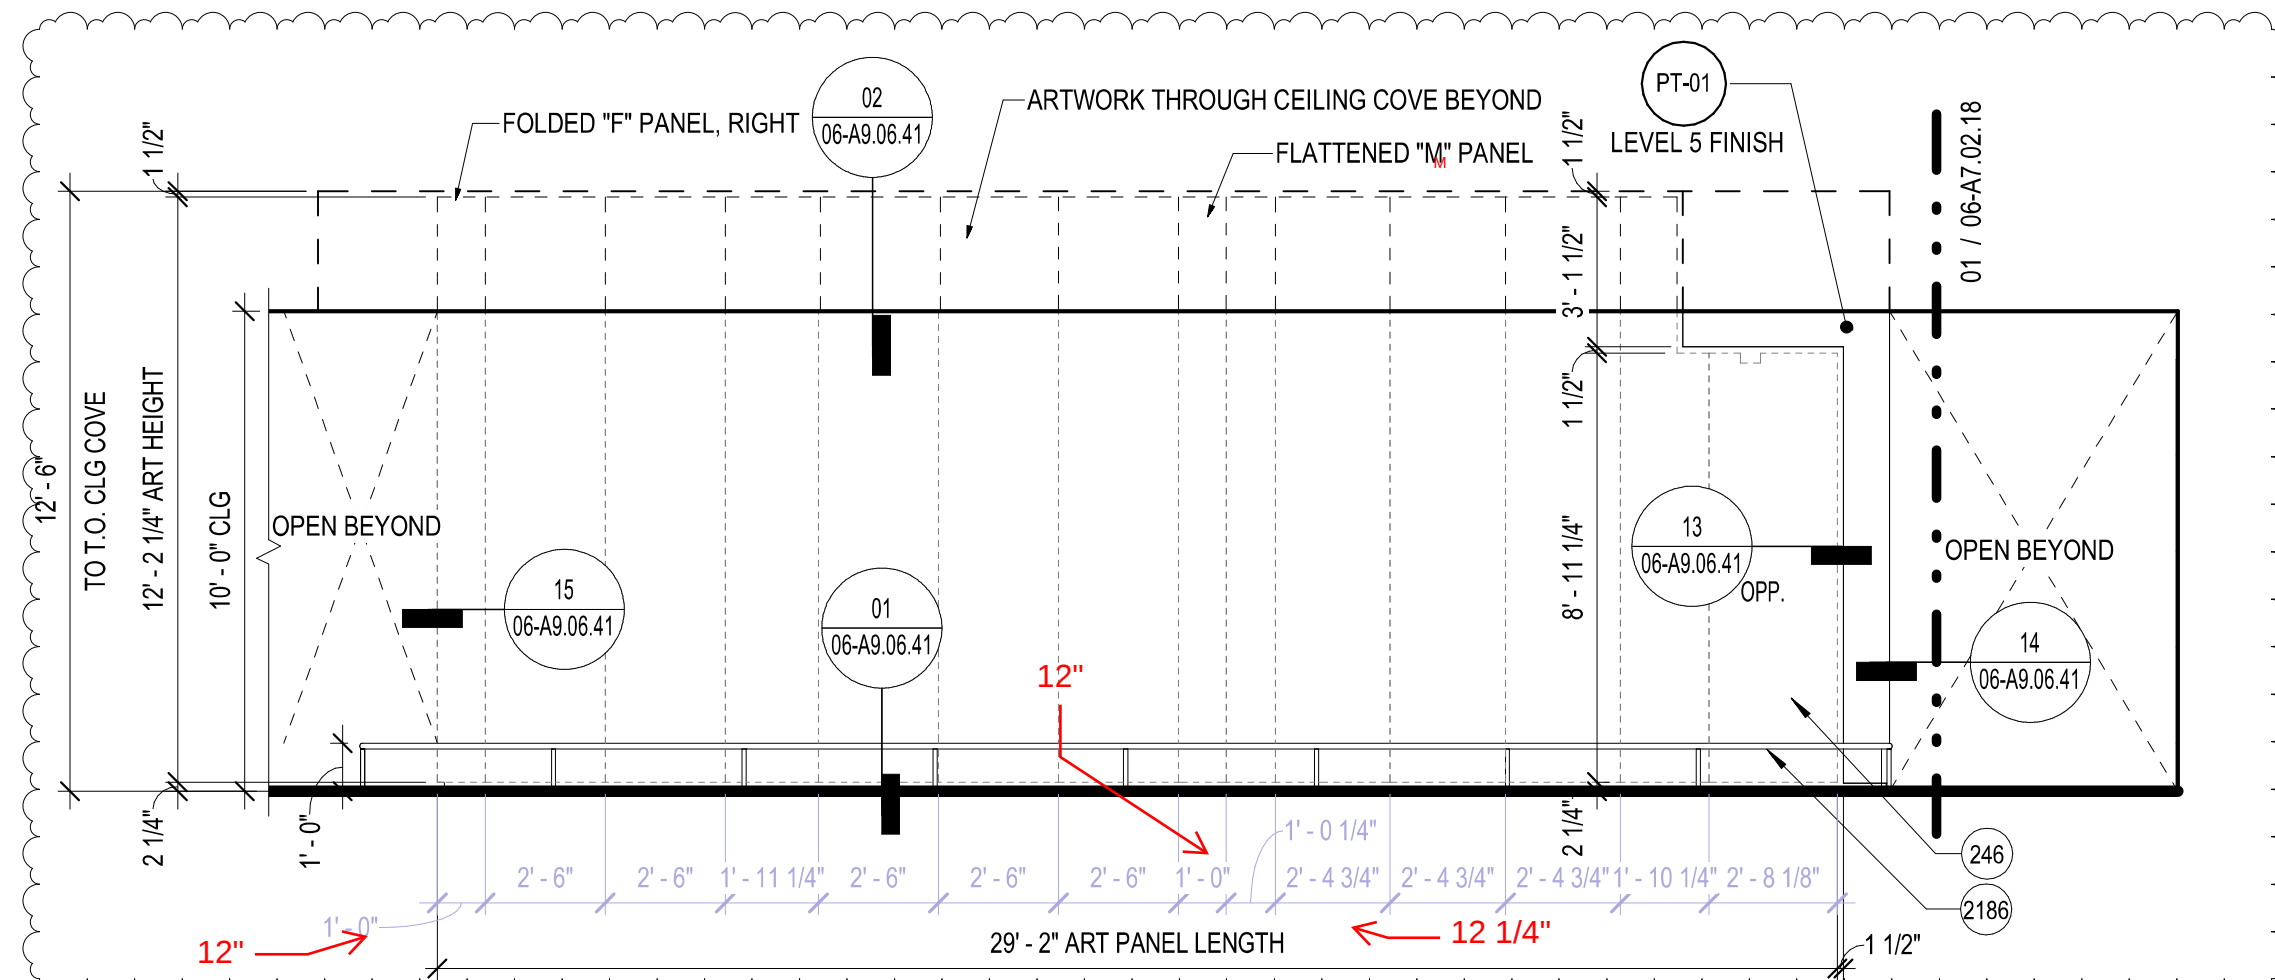

08 ELEV - 02 - 10 - CENTRAL CIRCULATION - F

SCALE: 1/4" = 1'-0"

SHEET NOTES

- 204 RAIL, CANE DETECTION, 1'-0" TALL MEASURED FROM TOP OF ADJACENT FLOOR, FINISH TO MATCH ADJACENT STAIR GUARDRAIL
- 219 STOREFRONT, BUTT JOINT GLAZING, SEE SPECS
- 246 ART LOCATION, TO BE PROVIDED BY SFAC, PROVIDE BACKING AS REQUIRED FOR ARTWORK
- 455 FIRE EXTINGUISHER CABINET, FULLY RECESSED
- 487 PHONE, COURTESY, SED, STOD
- 904 RECEPTACLES, TRASH & RECYCLING - MATERIAL SORTING BINS (MSB); SEE MSB DESIGN SPECIFICATIONS PACKAGE
- 921 MILLWORK BENCH, SLD
- 2051 AED CABINET, FULLY RECESSED
- 2186 CANE DETECTION GUARDRAIL
- 3005 FIRE HOSE VALVE CABINET, FULLY RECESSED, SFPD, PAINT PT-01 U.O.N., SEE ELEVATIONS.



GENERAL NOTES

1. SEE SPECIFICATION DIVISION 09 FOR ADDITIONAL FINISH INFORMATION.
2. REFER TO A0 SERIES FOR FINISH SCHEDULE INFORMATION.
3. FOR FINISHES OF WALLS THAT ARE NOT ELEVATED, REFER TO A0 SERIES FOR ROOM FINISH SCHEDULE.
4. REFER TO A0 SERIES DRAWINGS, DOOR SCHEDULE, AND SPECIFICATIONS FOR DOOR INFORMATION.
5. REFER TO A4 OR A6 SERIES FOR FLOOR FINISH INFORMATION.
6. REFER TO A6 SERIES FOR ENLARGED PLANS AND ELEVATIONS WITH ADDITIONAL FINISH AND DEVICE INFORMATION.
7. ALL GYP BD WALLS TO BE PAINTED PT-01 UNO.
8. ALL WALL BASE TO BE MT-01 U.O.; PROVIDE EQUAL CUT LENGTHS AT EACH END OF WALL WITH A DIMENSION OF NO LESS THAN 24".
9. PATCH, REPAIR AND CLEAN ALL (S) TO REMAIN FINISHES TO AS-NEW APPEARANCE. PATCH WALLS AT DEMO WALL PARTITIONS TO MATCH ADJACENT FINISHES.
10. ALL PARTITIONS TO RECEIVE LEVEL 4 FINISH U.O. REFER TO SPECIFICATIONS
11. ENSURE ALL SURFACES RECEIVING FINISHES ARE CLEAN, TRUE AND FREE OF IRREGULARITIES. DO NOT PROCEED WITH WORK UNTIL UNSATISFACTORY CONDITIONS HAVE BEEN CORRECTED.
12. REFER TO ELEVATIONS FOR GLAZING AND FILM INFORMATION.
13. REFER TO A9 SERIES FOR TYPICAL WALL PANEL, JOINT, CORNER TREATMENT, COLUMN COVER, HEADER, GLAZING, DOOR, AND OPENINGS DETAILS.
14. REFER TO A10 SERIES SHEETS FOR FURNITURE INFORMATION.
15. REFER TO VOLUME 4 SG SERIES SHEETS FOR SIGNAGE REQUIREMENTS AND SIGNAGE SUPPORTS.
16. SEE CIVIL, STRUCTURAL, MECHANICAL, ELECTRICAL, PLUMBING, AV, TELECOM, SECURITY, LIGHTING & PASSENGER BOARDING BRIDGES, BAGGAGE HANDLING SYSTEM, AND FIRE PROTECTION FOR ADDITIONAL WORK.
17. WHITE ELECTRICAL OUTLETS, RECEPTACLE COVERS, SWITCHES AND SWITCH PLATES TO BE USED U.O. REFER TO ELEVATIONS FOR LOCATIONS OF NON-WHITE APPLICATIONS TO CORRESPOND WITH WALL FINISH.
18. FINAL ADVERTISING LAYOUT TO BE DETERMINED.
19. REFER TO ELECTRICAL, POWER AND TELECOMMUNICATION DRAWINGS FOR FURTHER INFORMATION ON POWER AND DATA LOCATIONS TO BE COORDINATED WITH FINISHES.
20. PUBLIC AND SUPPORT SPACE CORNER GUARDS TO BE PROVIDED AND INSTALLED AT ALL EXPOSED CORNERS.
21. ALL SUPPORT SPACE CORNER GUARDS TO BE RESILIENT. SEE SPECIFICATIONS FOR PRODUCT INFORMATION.
22. PROVIDE WALL PROTECTION WAINSCOT PANELING WITH PVC-FREE BUMPER RAILS AT TOP AND BOTTOM AND CORNERS, AT ALL SERVICE CORRIDORS AND VESTIBULES, UNO.
23. A WAINSCOT OF FIRE TREATED PLYWOOD TO BEGIN 6" AFF AND END AT 8'-6" AFF TO BE PROVIDED AT ALL SSR, TENANT WIRING CLOSETS, ELECTRICAL METERING ROOMS, ZONE CLOSETS, CELLULAR DAS, AND IDF ROOM UNO.
24. HATCHES ARE DIAGRAMMATIC AND INTENDED TO INDICATE DIFFERENT FINISH TYPES ONLY; HATCHES DO NOT REPRESENT PRODUCT INSTALLATION DIRECTION OR LAYOUT.
25. ALL NICHES TO HAVE A 9'-1" SOFFIT AFF, U.O. REFER TO RCP.


GRAPHICS LEGEND

- PT-XX WALL FINISH TAG - SEE A0 SERIES FINISH SCHEDULE FOR FINISH INFORMATION, LEADERS INDICATE THE EXTENT OF FINISH
- PT-XX SPECIALTY FINISH TAG - SEE A0 SERIES FINISH SCHEDULE FOR FINISH INFORMATION
- GLAZING, SEE AXX SERIES FOR MORE INFORMATION
- FURNITURE, EQUIPMENT AND SIGNAGE BY OTHERS
- NOT IN CONTRACT
- UNDER SEPARATE PERMIT PKG
- TO BE ISSUED IN FUTURE BULLETIN

KEY PLAN

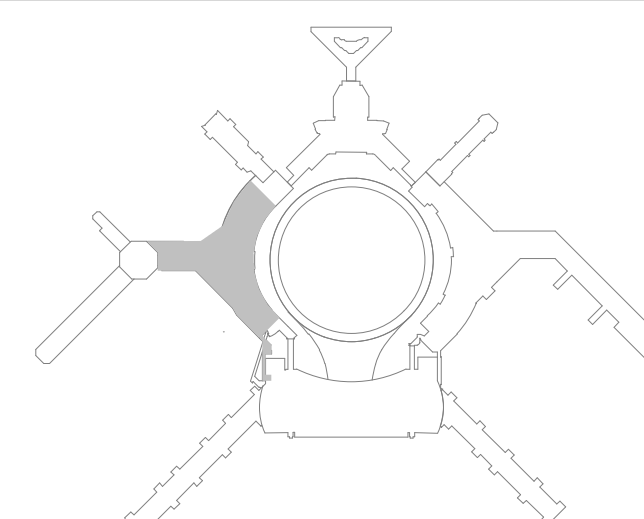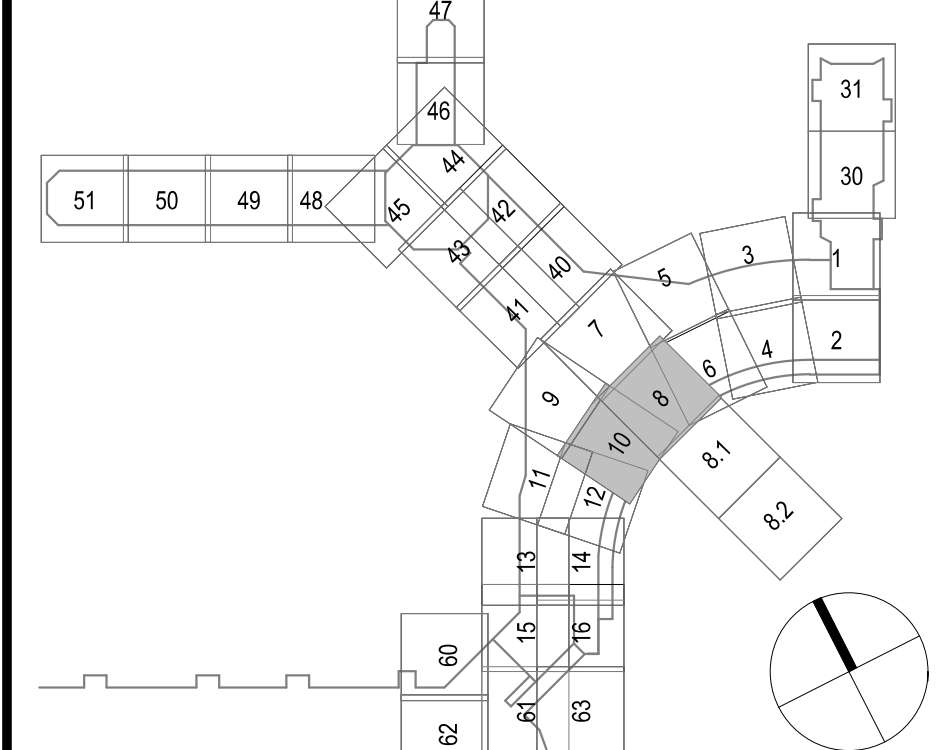



NO.	DATE	REVISIONS
1	08/28/2025	ONCOMING DESIGN CHANGES AND REVISIONS TO BE CONFORMED
2	11/14/2025	BICE PACKAGE 6 - ISSUE FOR PERMIT
3		BICE PACKAGE 6 - DESIGN CHANGES

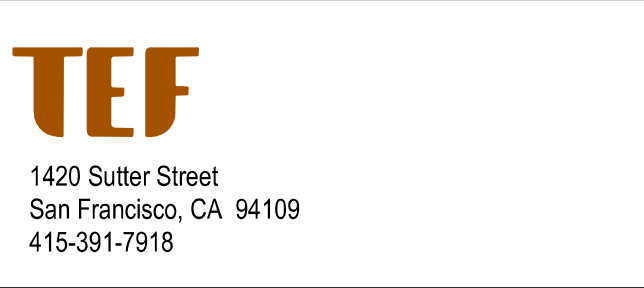

CONTRACT NO.	10071.76_400
PROJECT TITLE	TERMINAL 3 WEST MODERNIZATION
SHEET TITLE	PACKAGE 6 - VOL 3
	INT ELEV - LEVEL 2 - CENTRAL CIRCULATION


APPROVED:	
APPROVED:	
DESIGNED BY:	CHECKED BY:
DRAWN BY:	DATE:
SCALE:	02/28/2025
1/4" = 1'-0"	SIZE:
SHEET NUMBER	ARCH-E1

06-A7.02.34


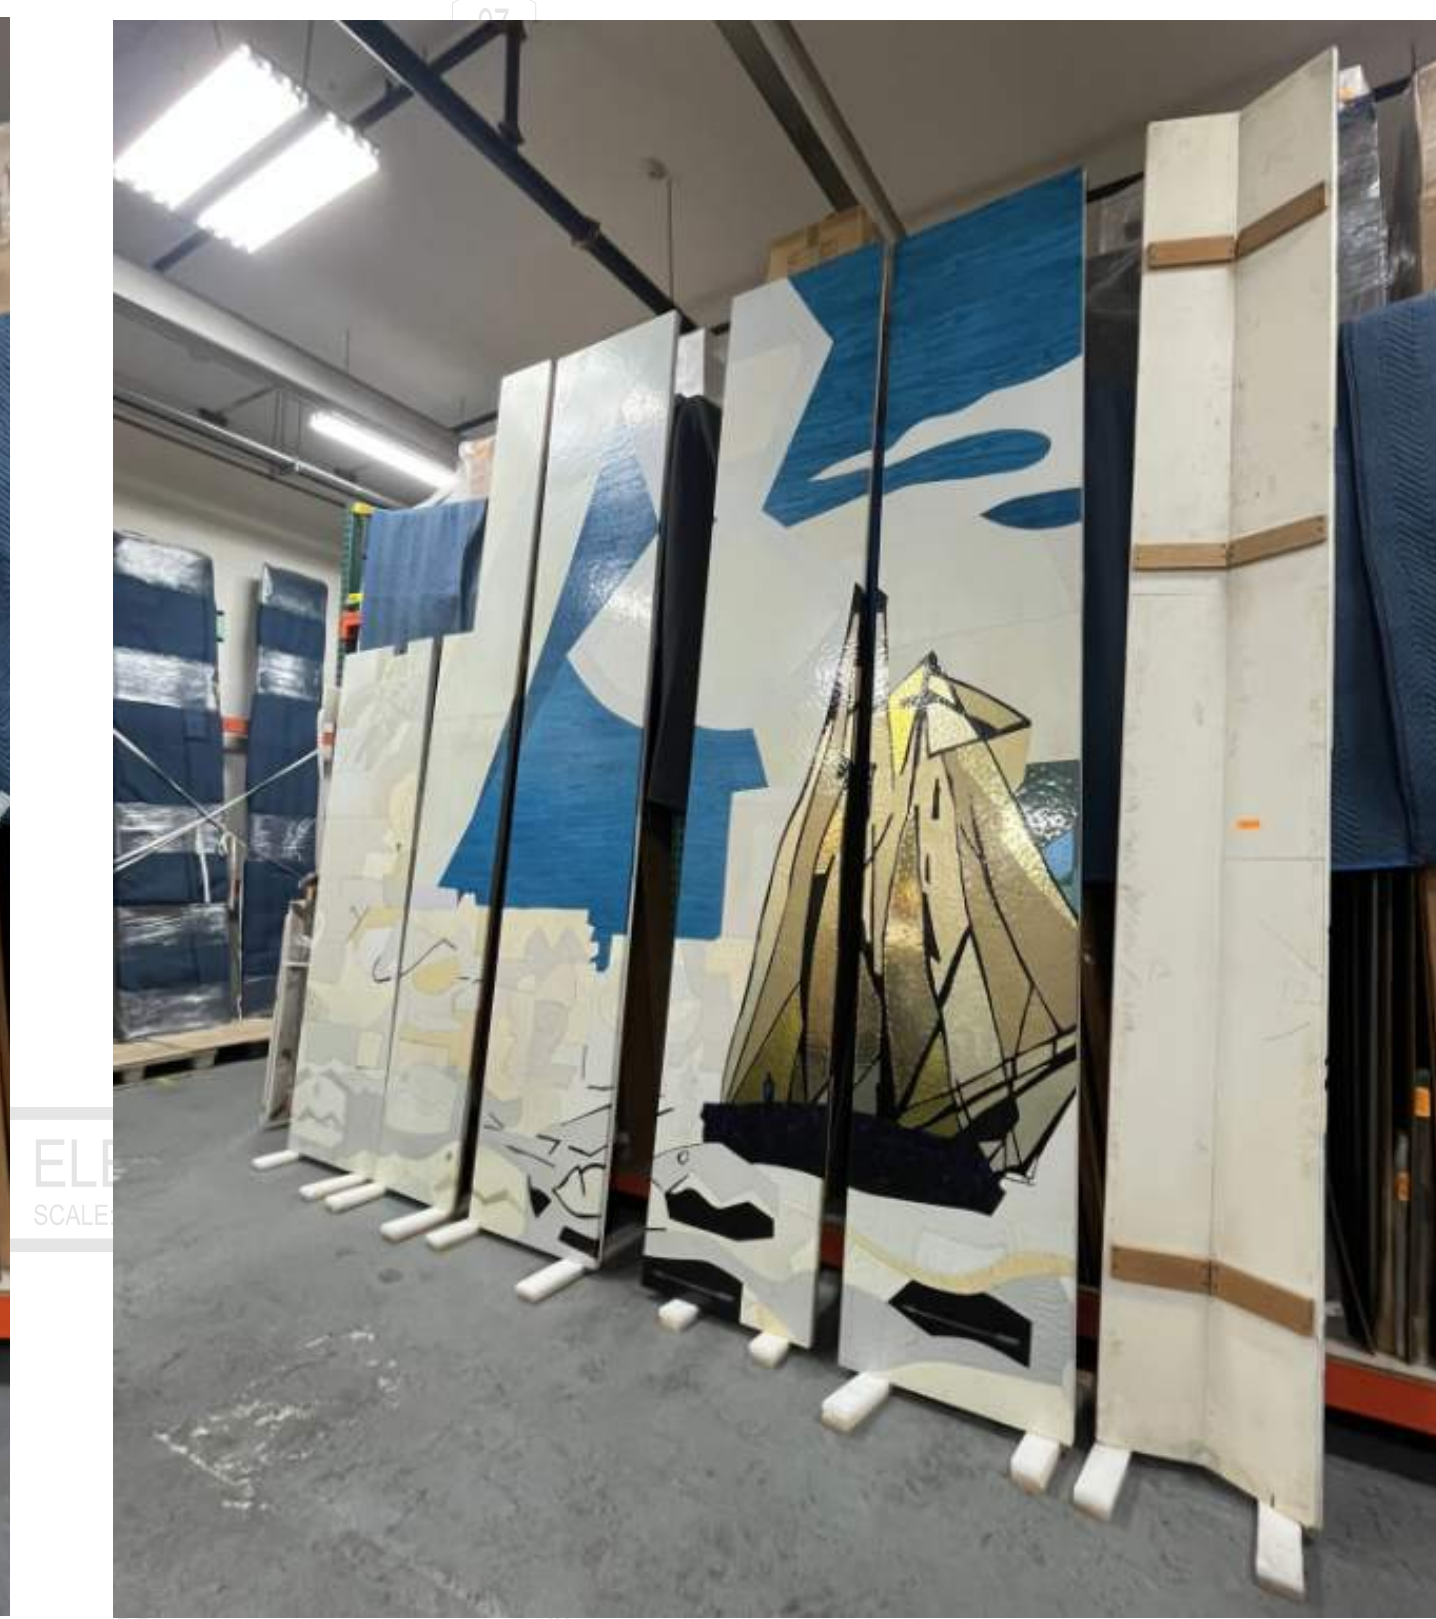
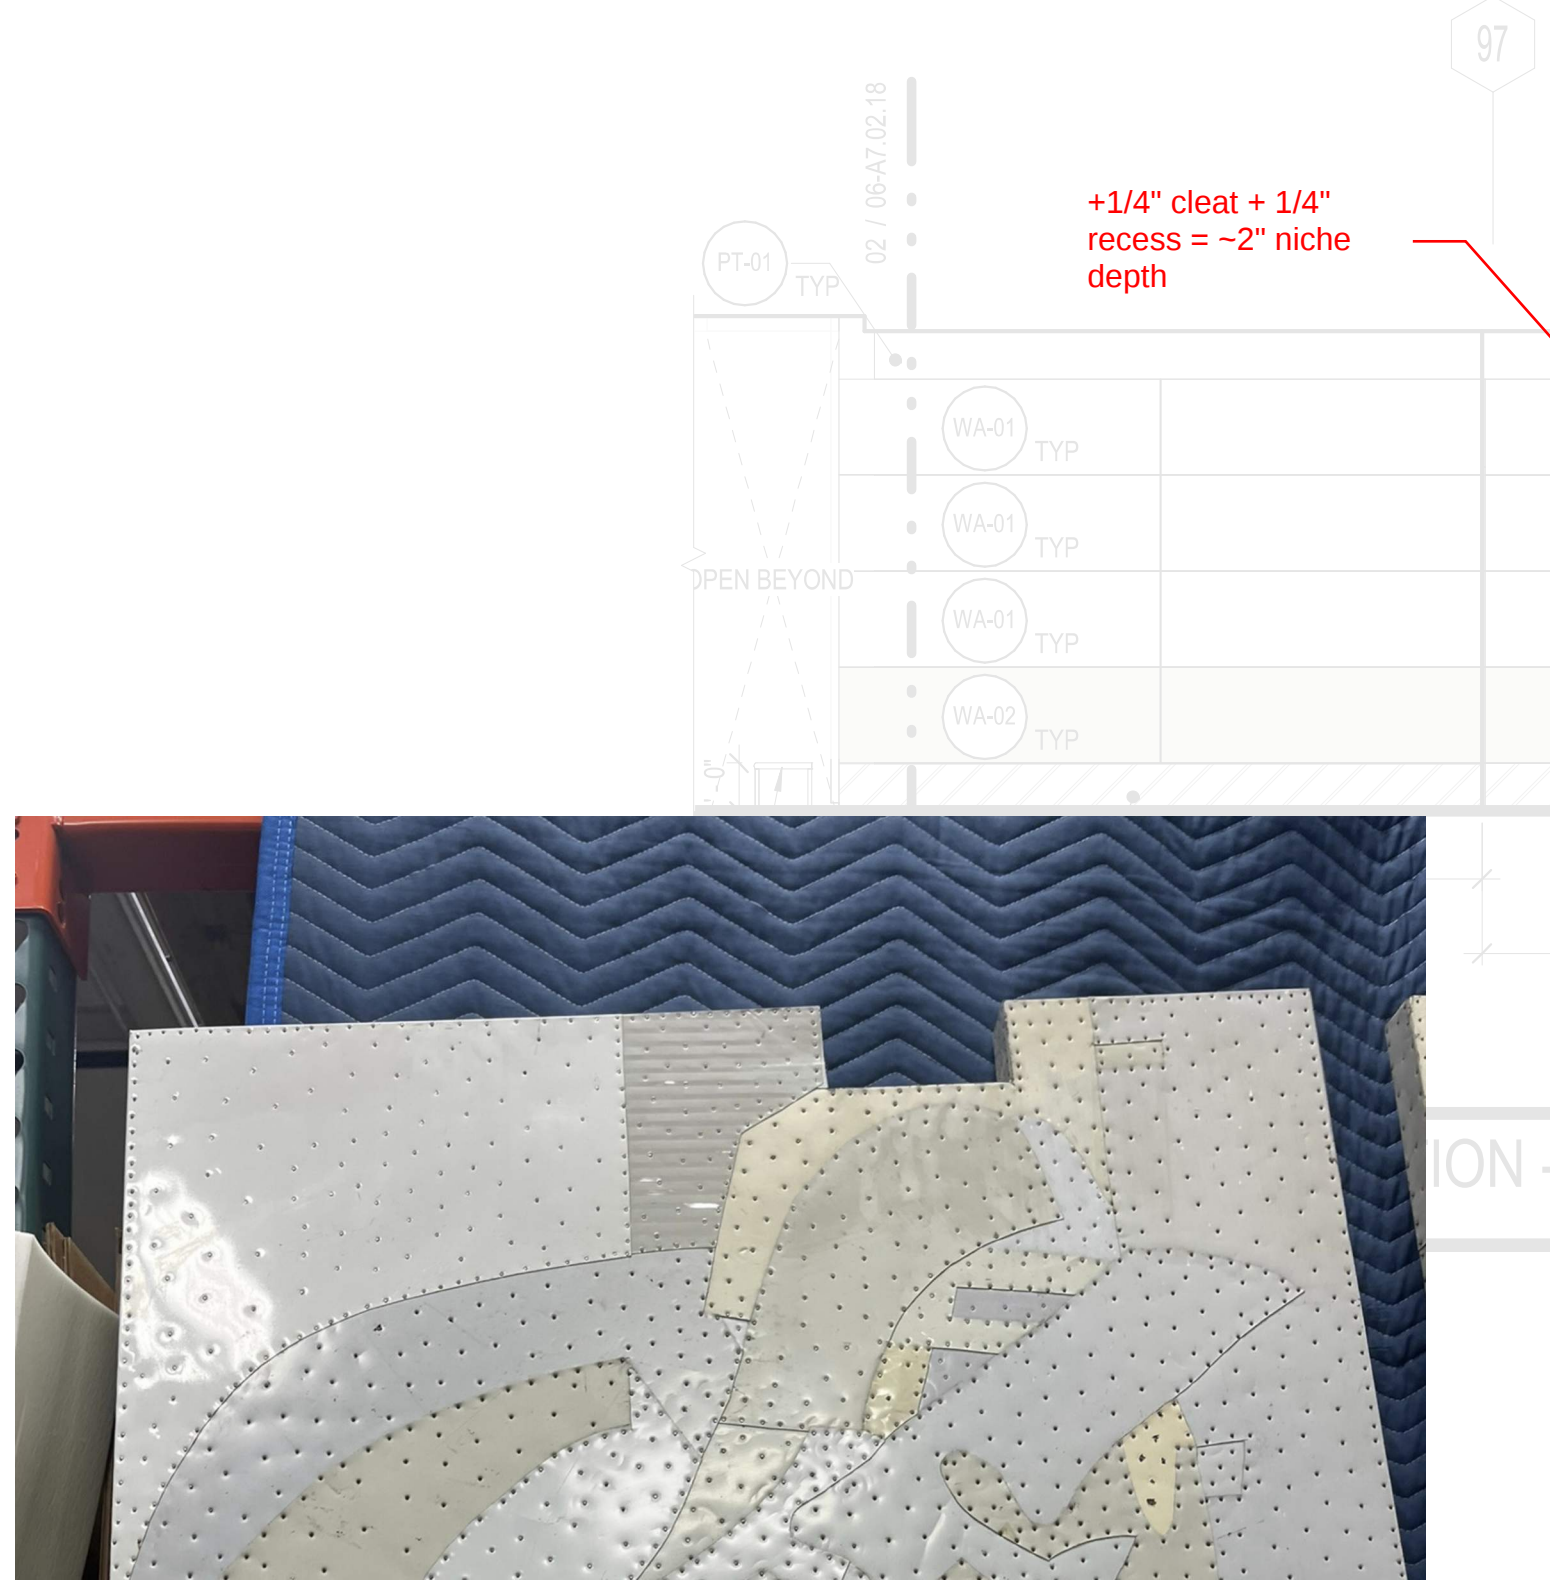


04 ELEV - 02 - 08 - CENTRAL CIRCULATION - A

SCALE: 1/4" = 1'-0"

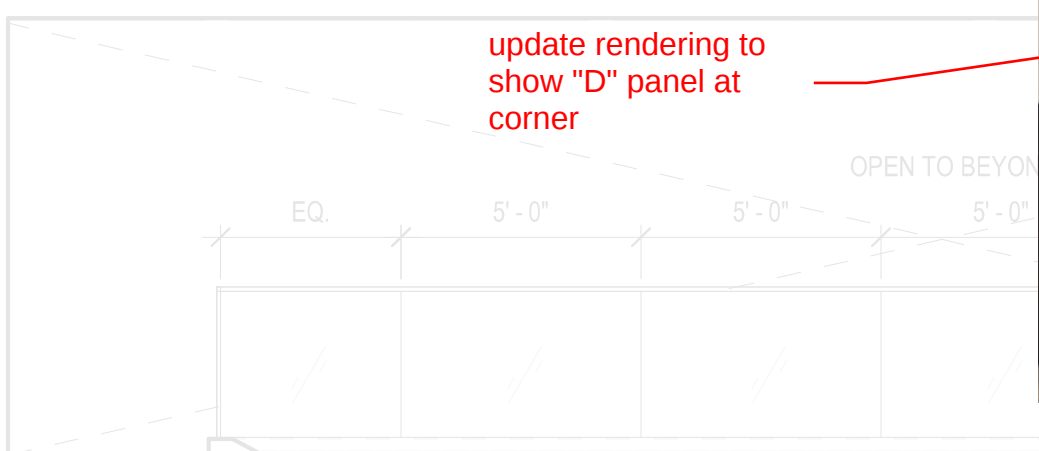

update rendering to show "D" panel at corner

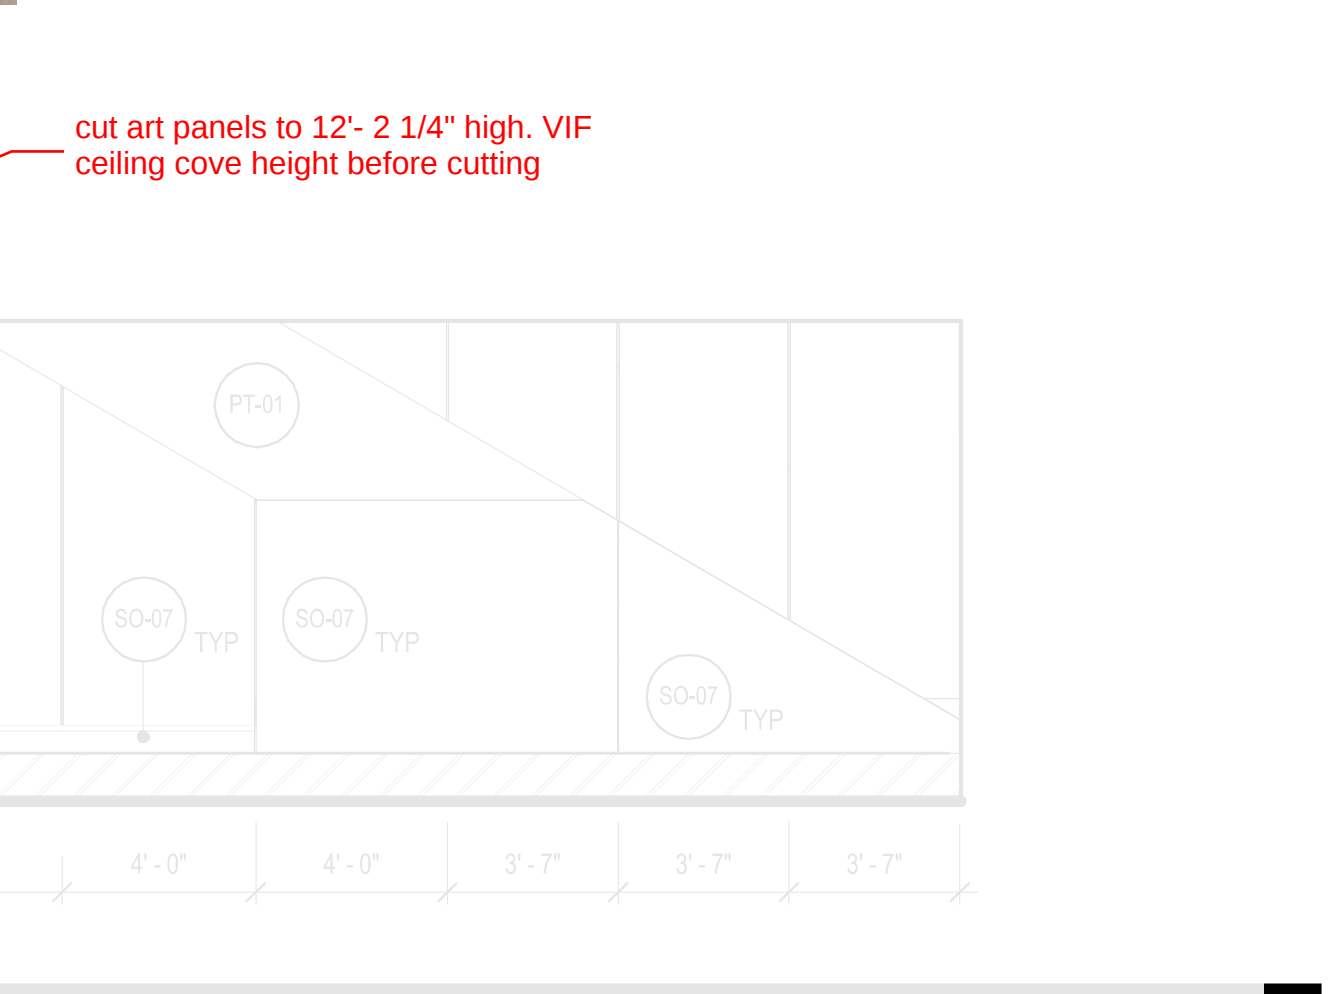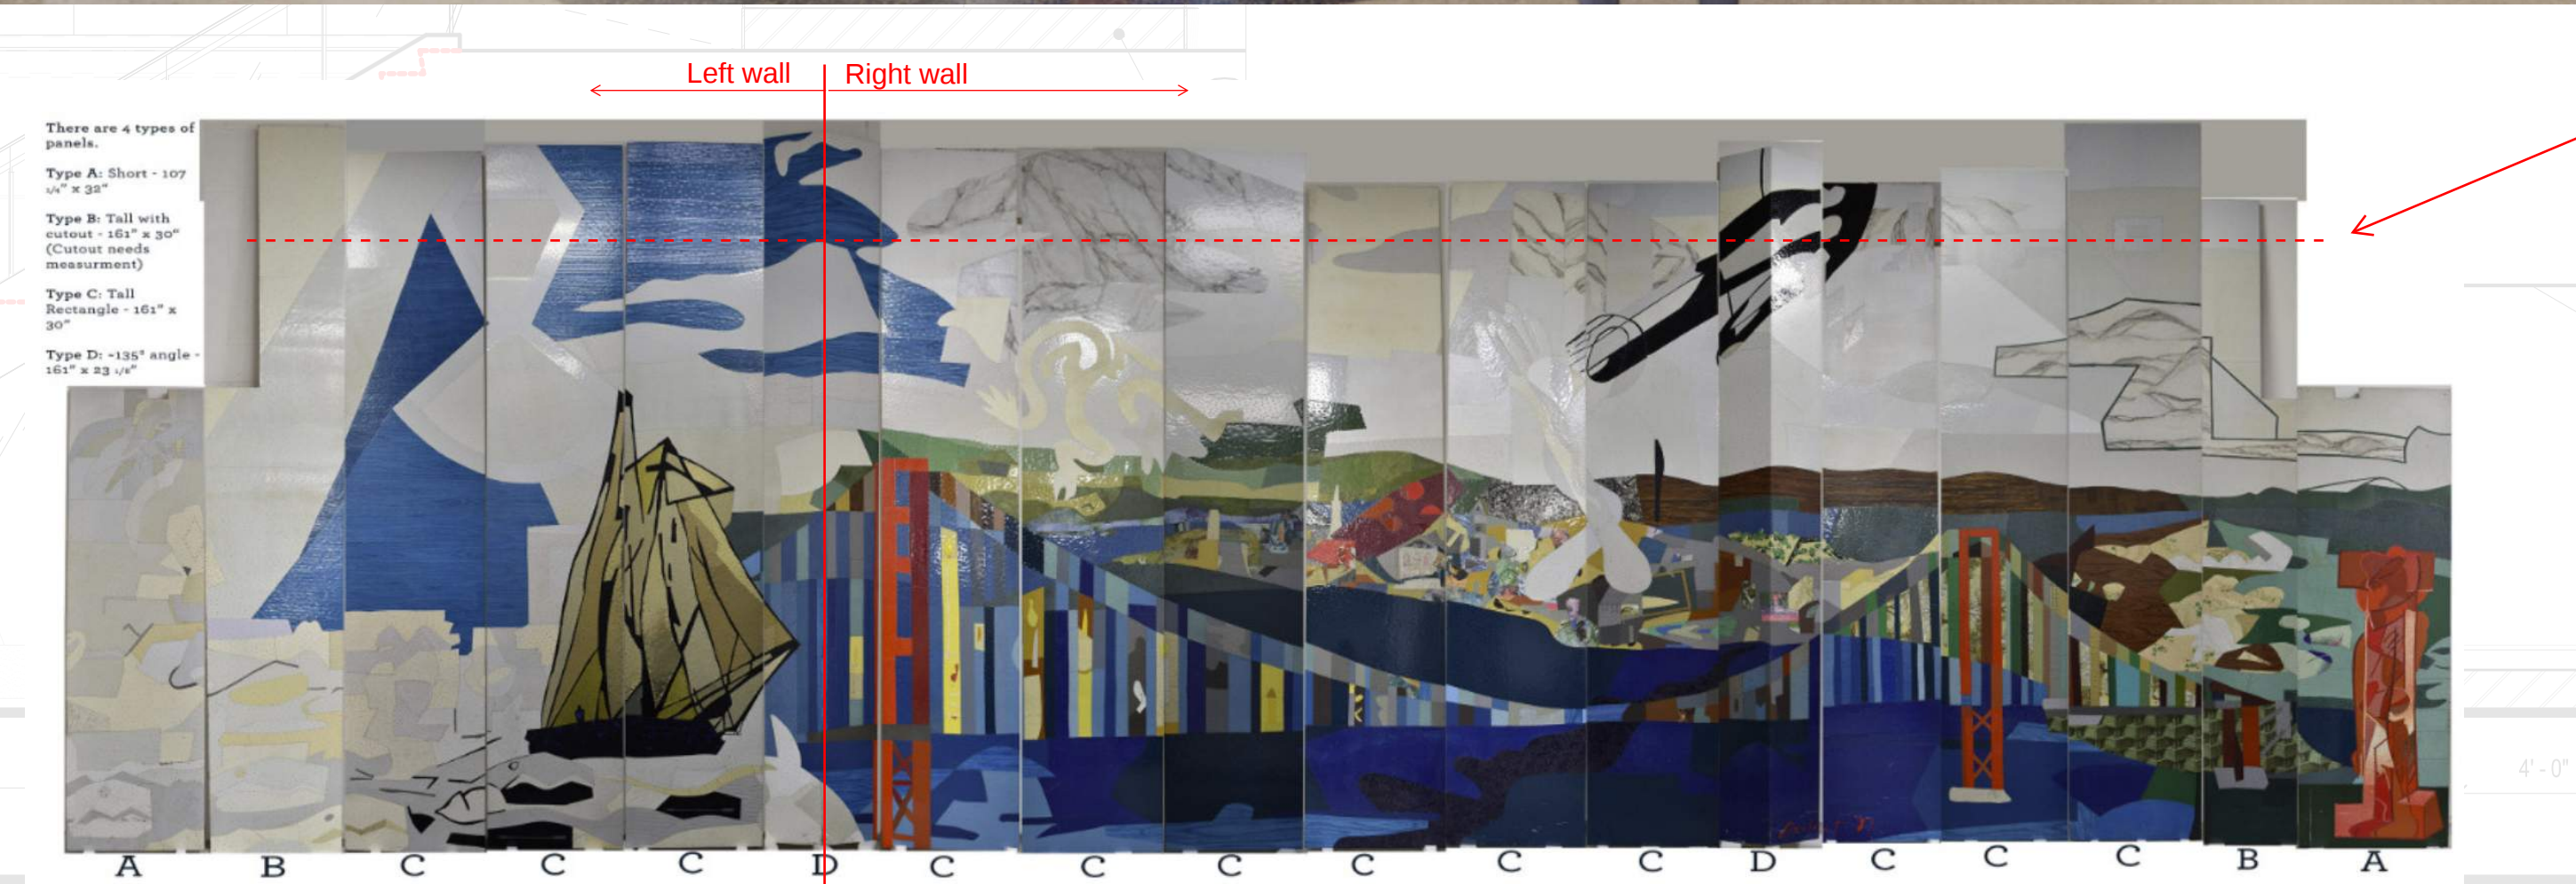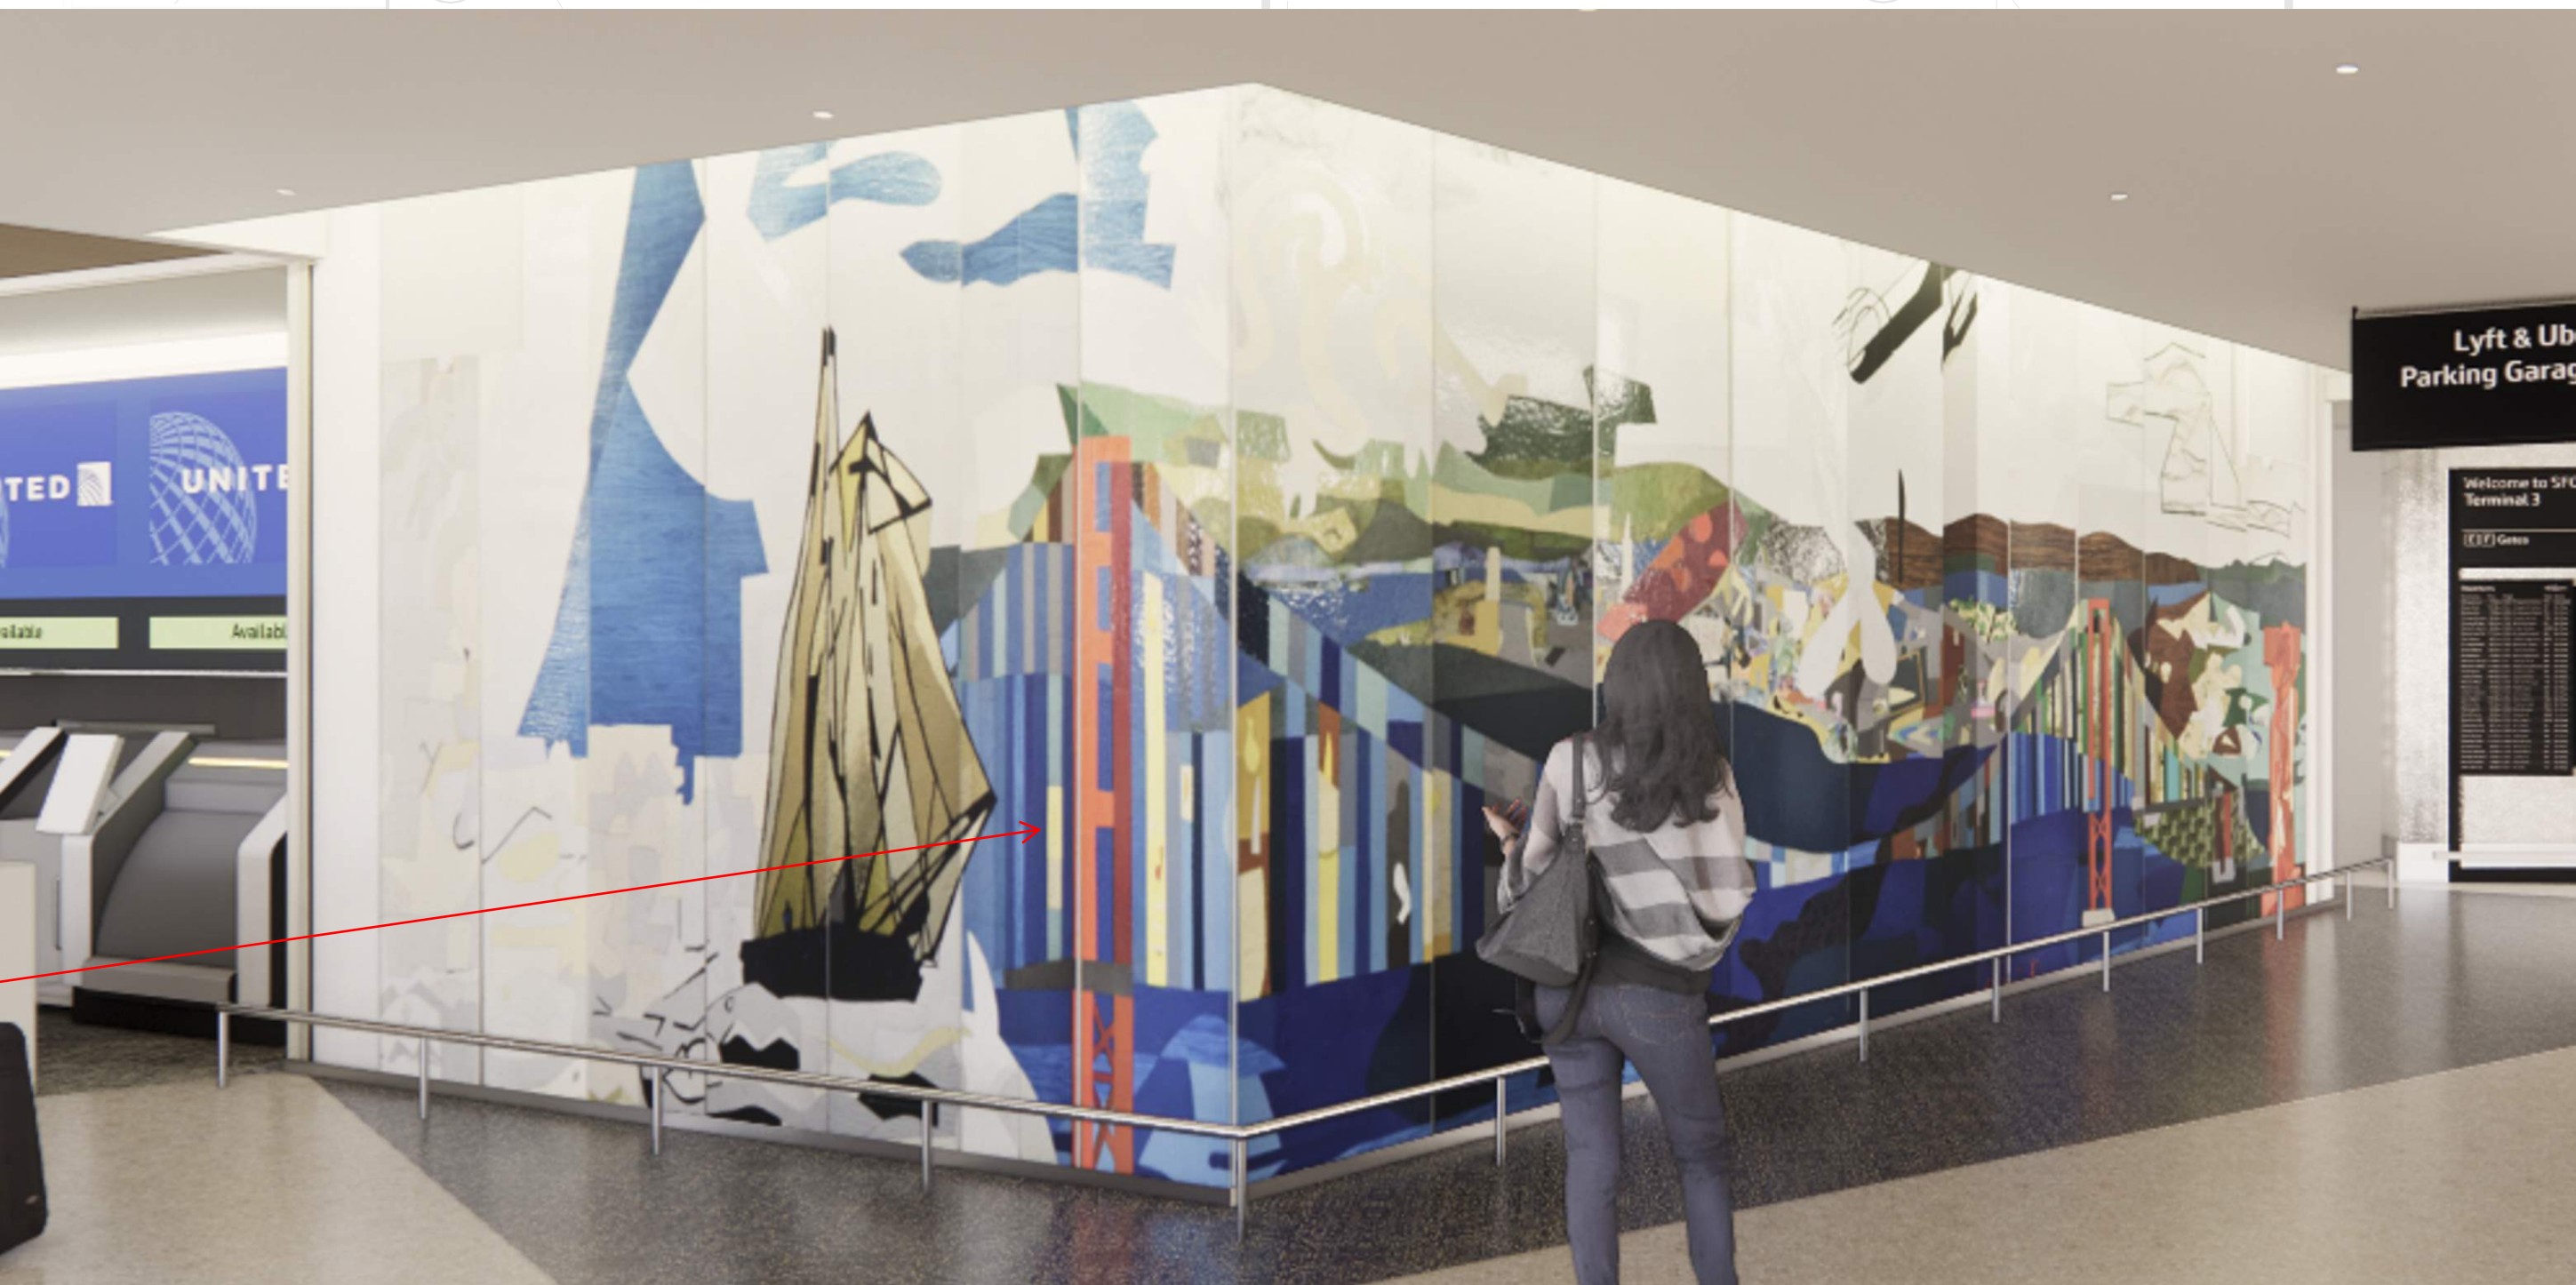


02 ELEV - 02 - 10 - WHEELCHAIR STORAGE BENCH


SCALE: 1/4" = 1'-0"

01 ELEV - 02 - 10 - CENTRAL CIRCULATION - G

SCALE: 1/4" = 1'-0"

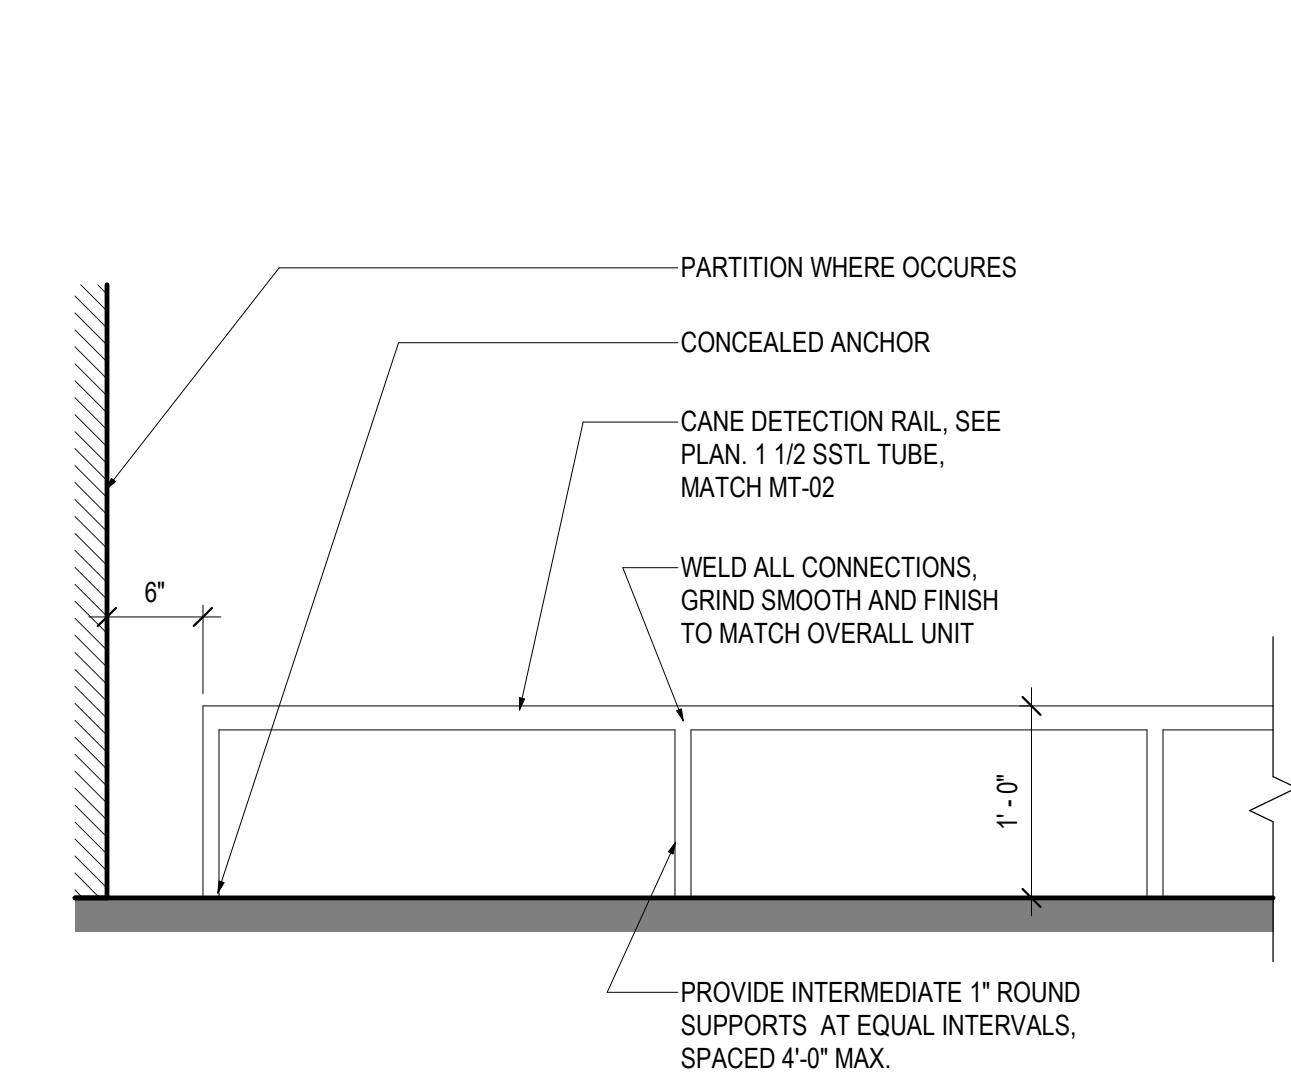


12 CANE DETECTION RAIL
SCALE: 1" = 1'-0"

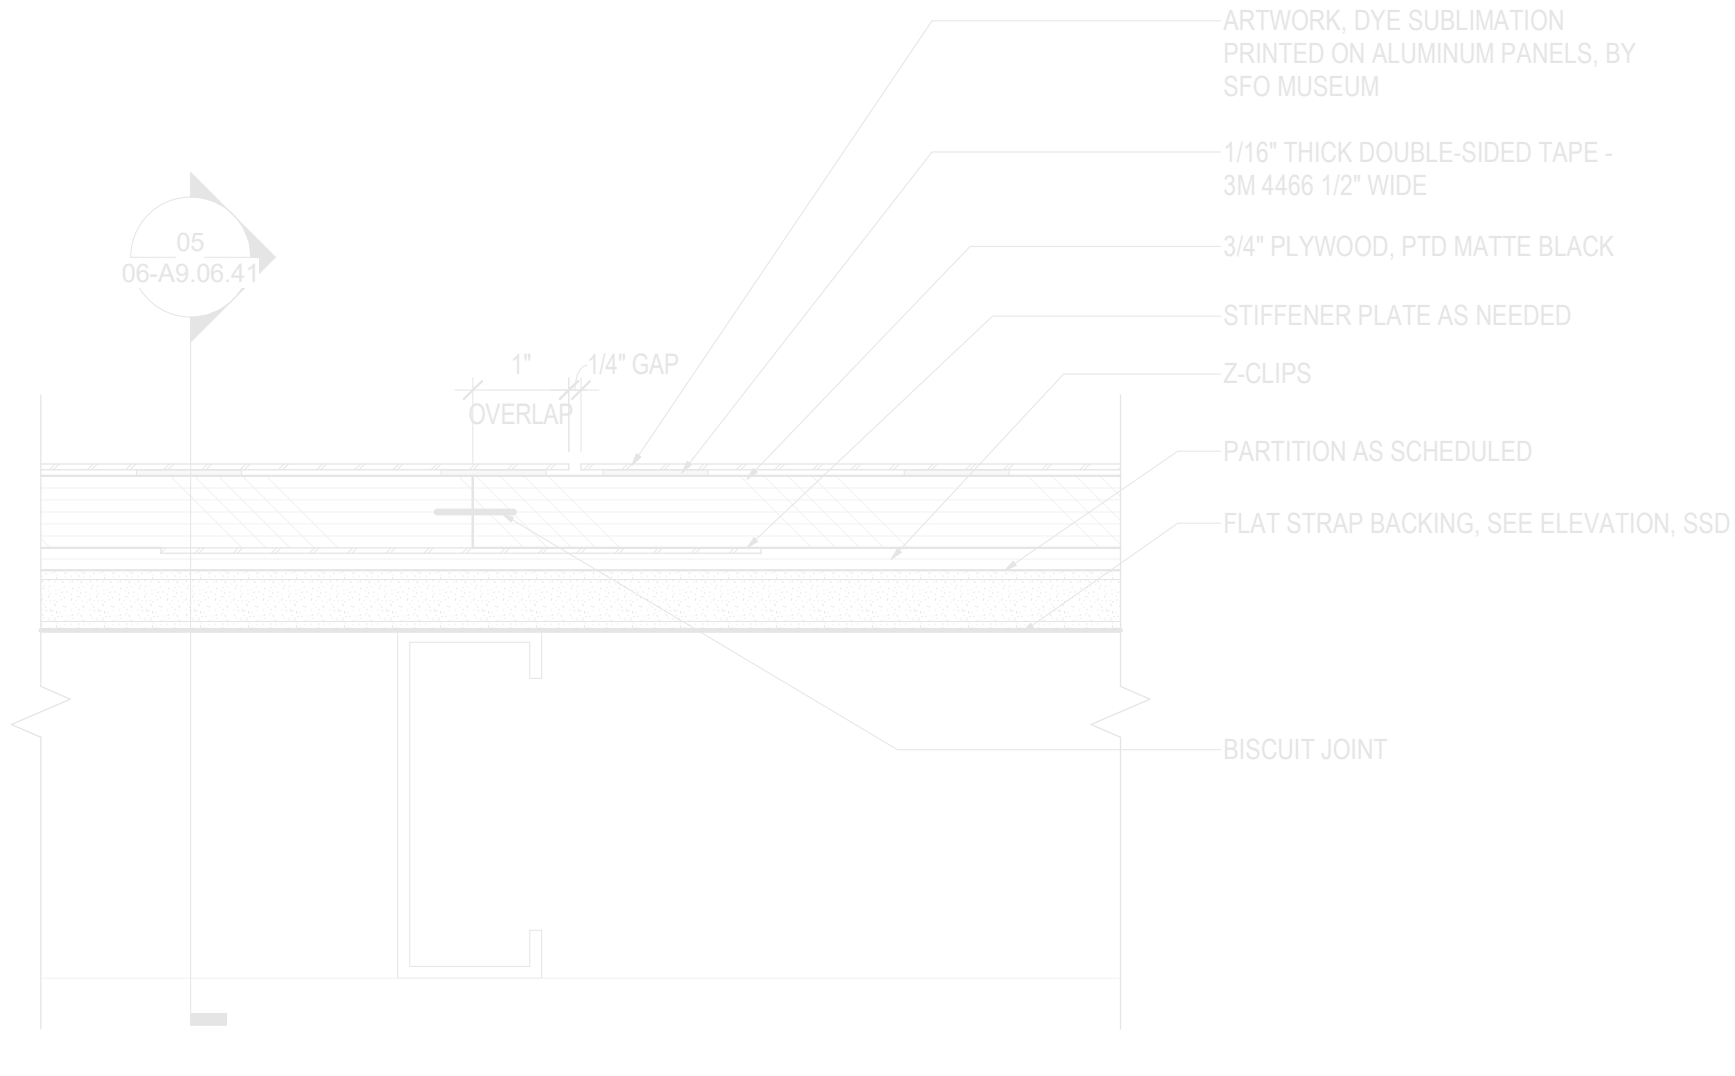


08 DETAIL - 2D ART - PANEL JOINT
SCALE: 6" = 1'-0"




04 DETAIL - ART NICHE - SSTL BLADE
SCALE: 3\"/>

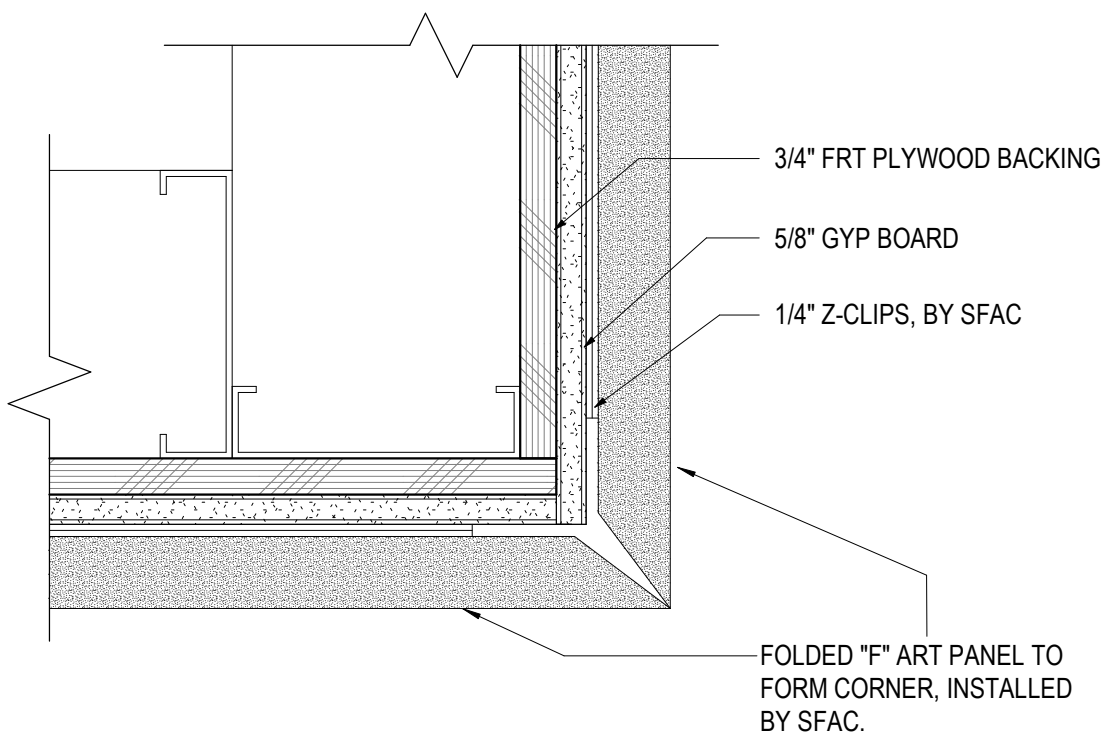


15 DETAIL - ART CORNER PANEL - TONY BERLANT
SCALE: 3\"/>

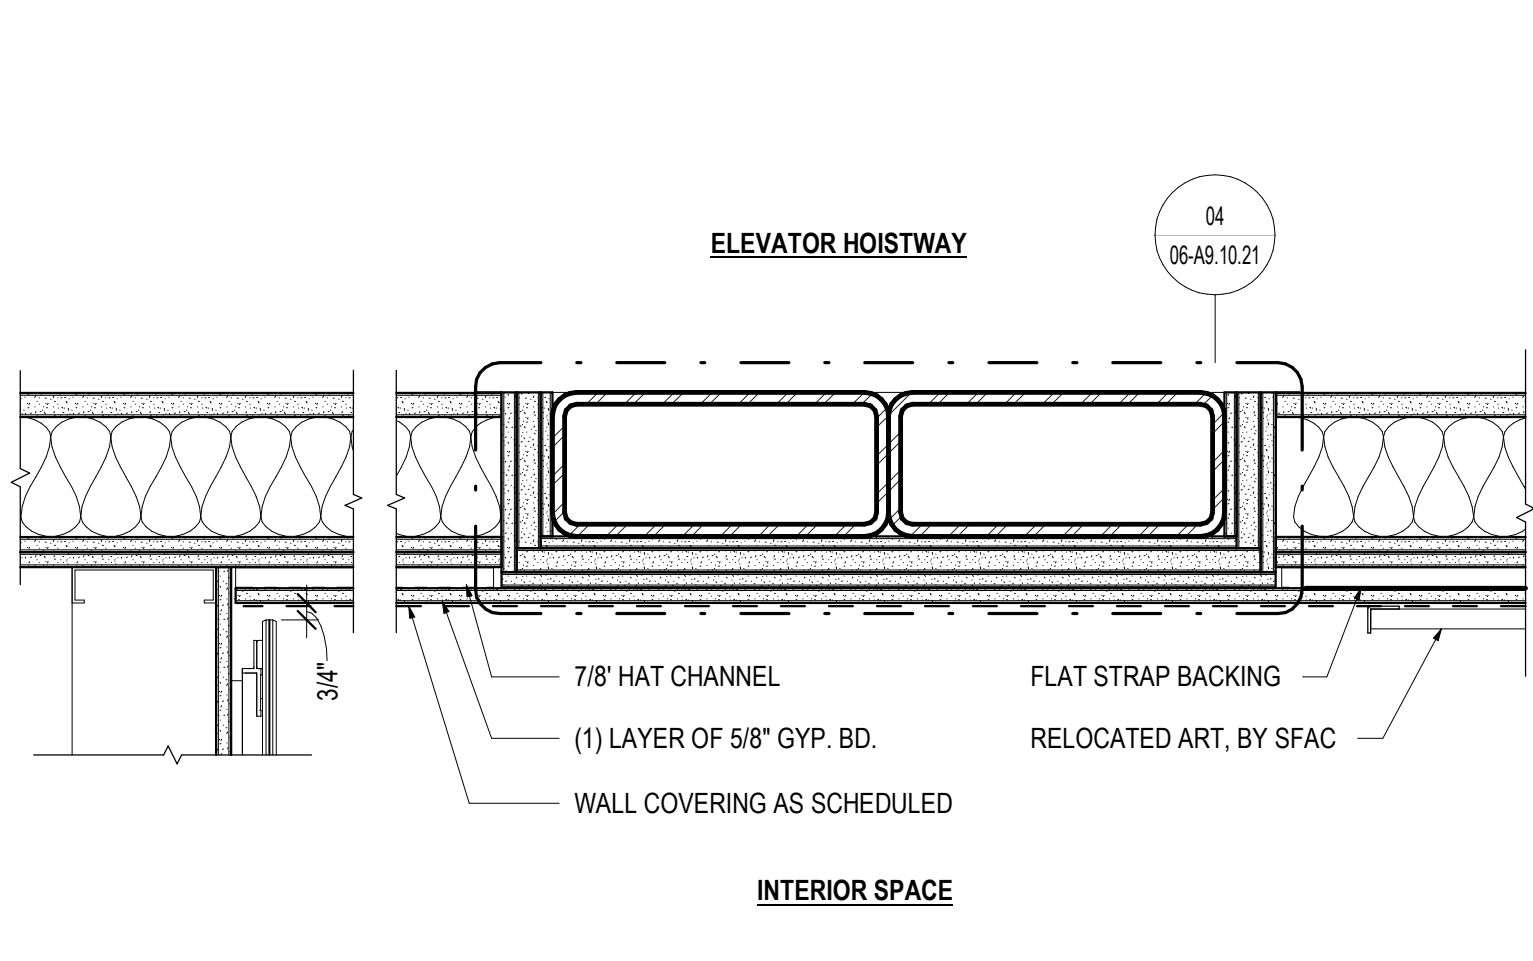


11 PLAN DETAIL - INTERIOR CORNER @ ART NICHE
SCALE: 1 1/2\"/>

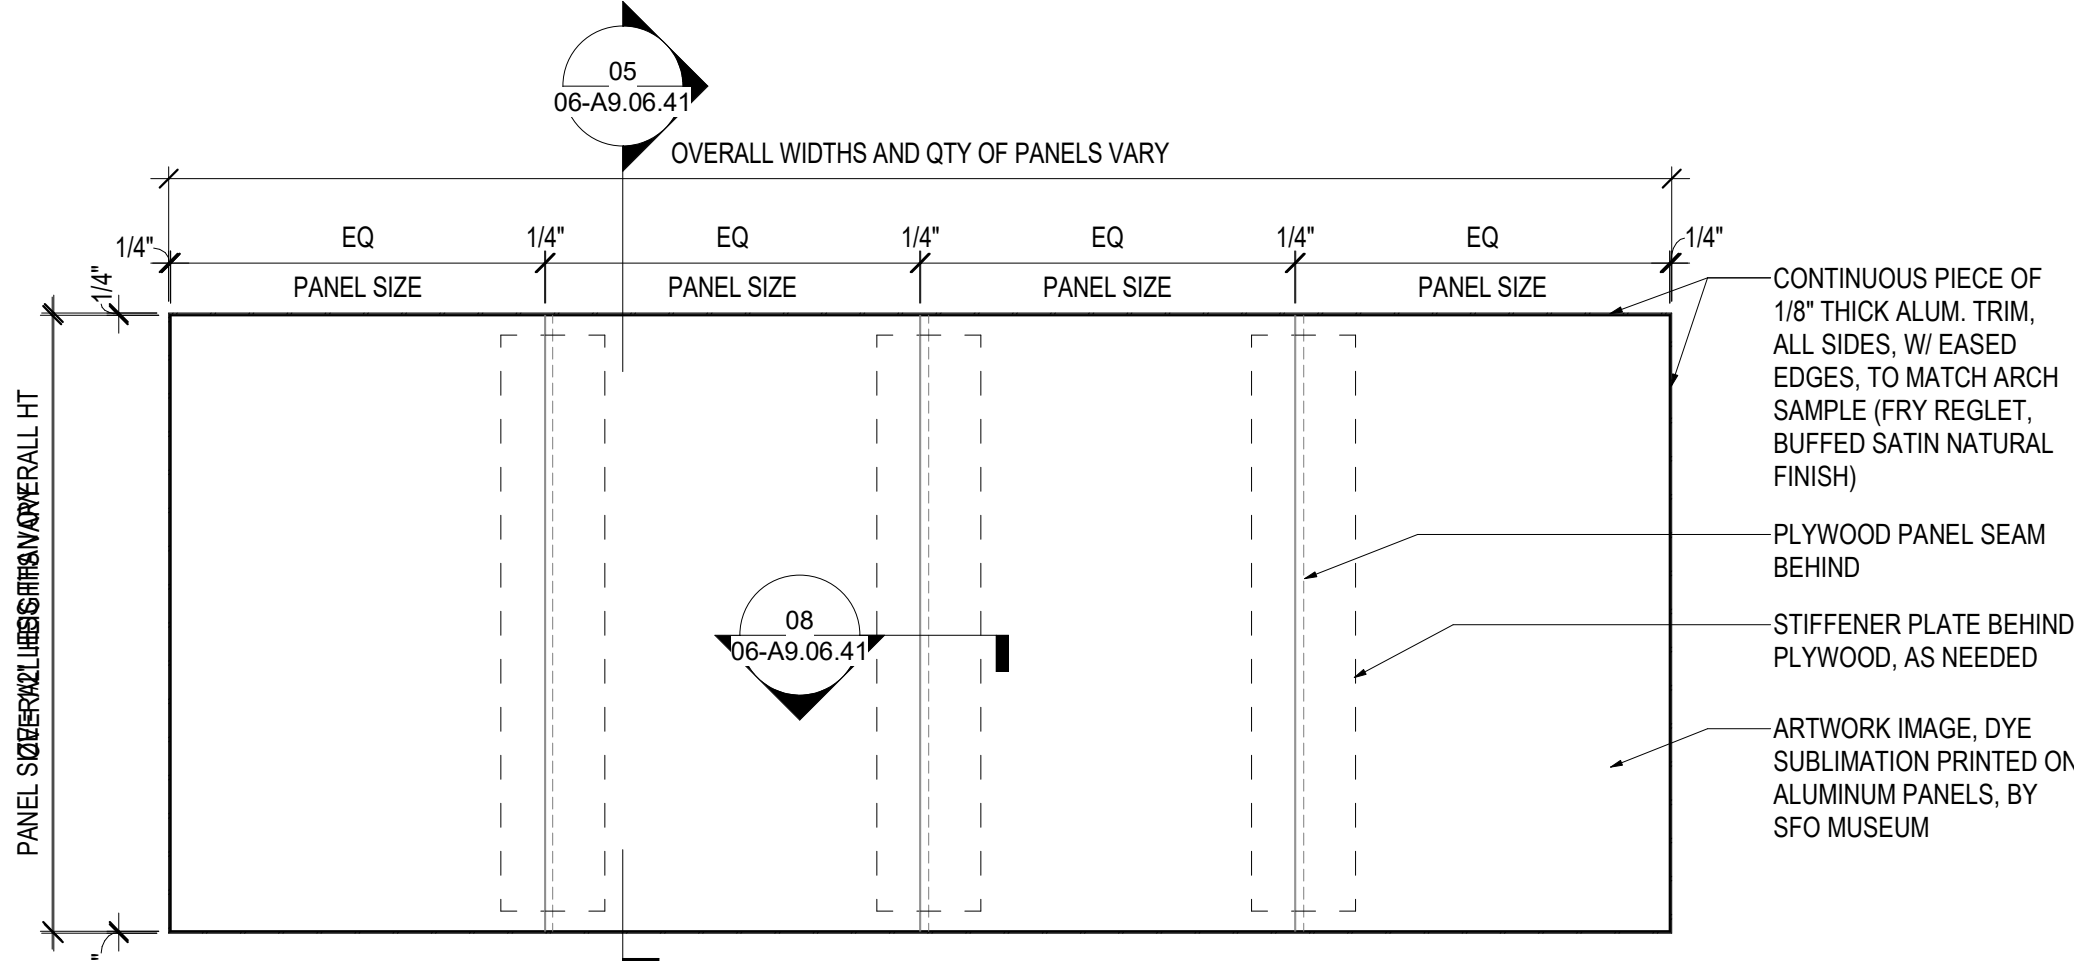


07 DETAIL - 2D ART - ELEVATION
SCALE: 1/2\"/>

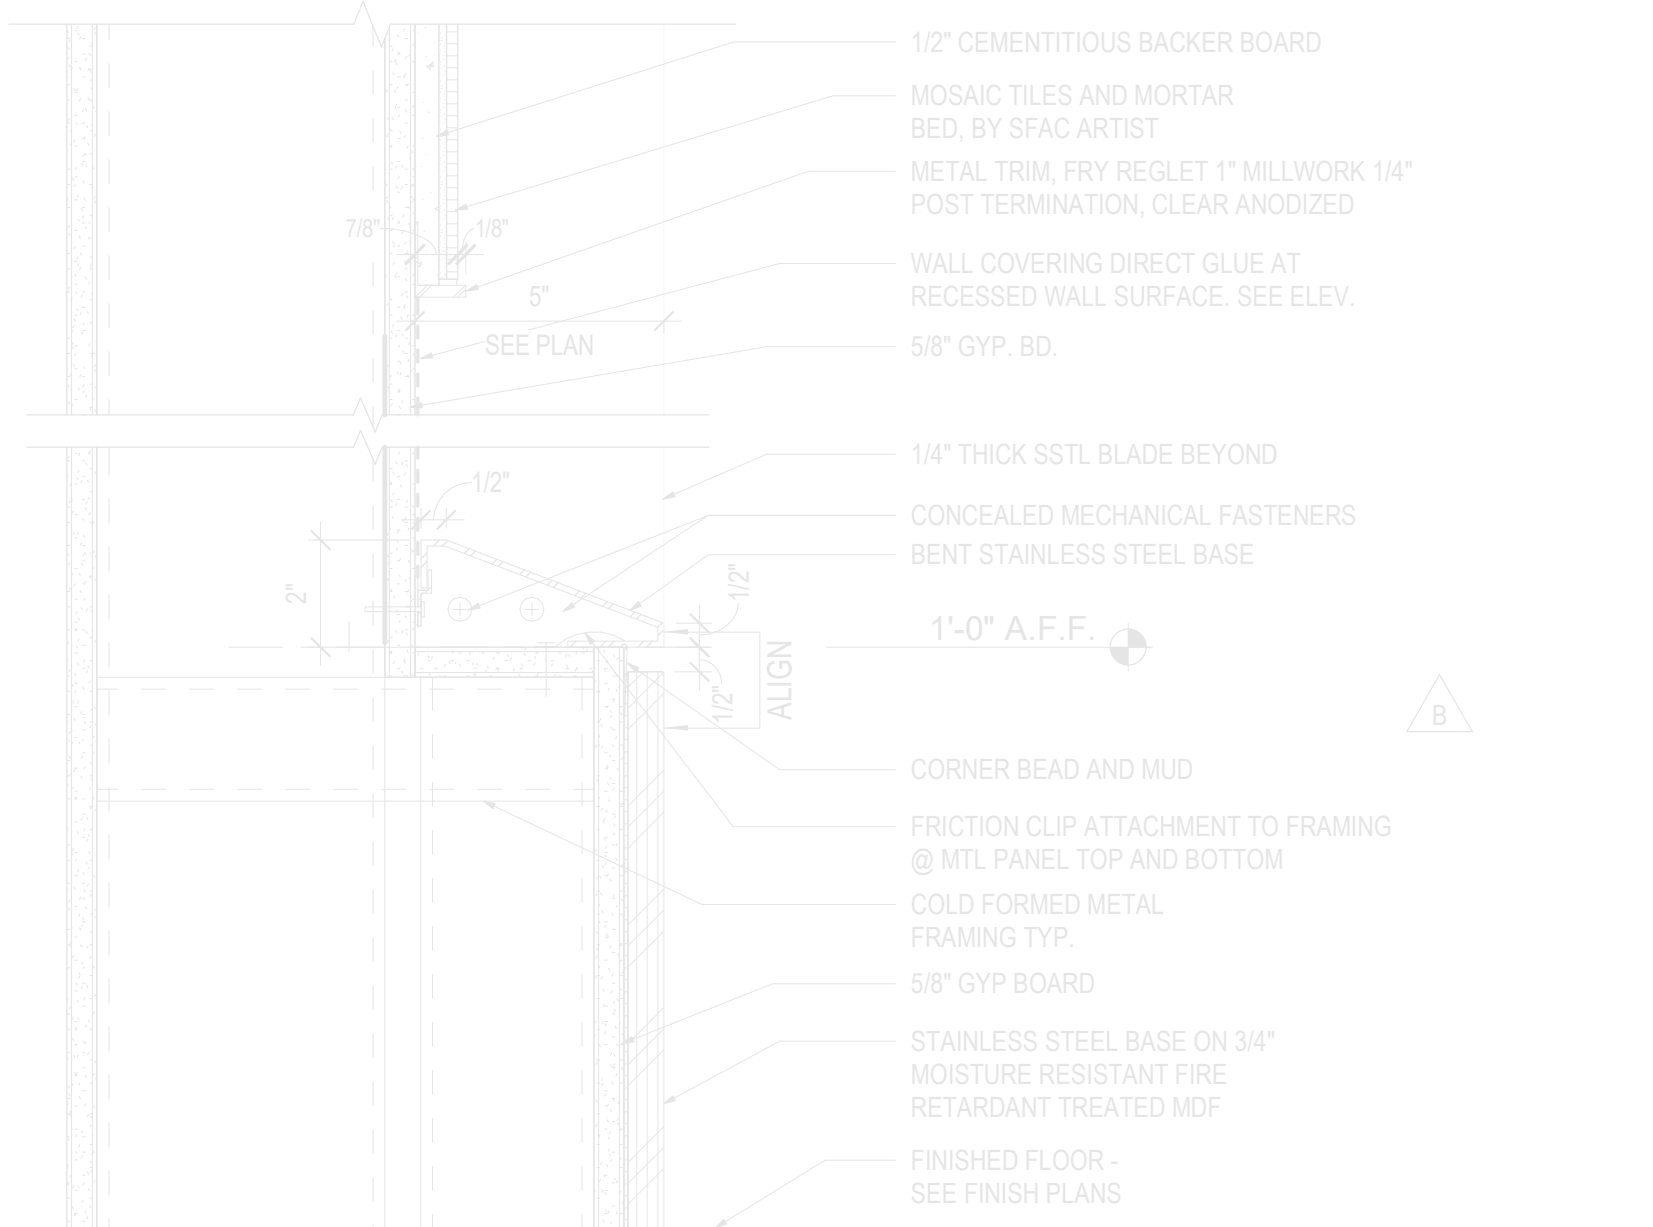


03 DETAIL - SLOPED SSTL BASE AT ART WALL
SCALE: 3\"/>

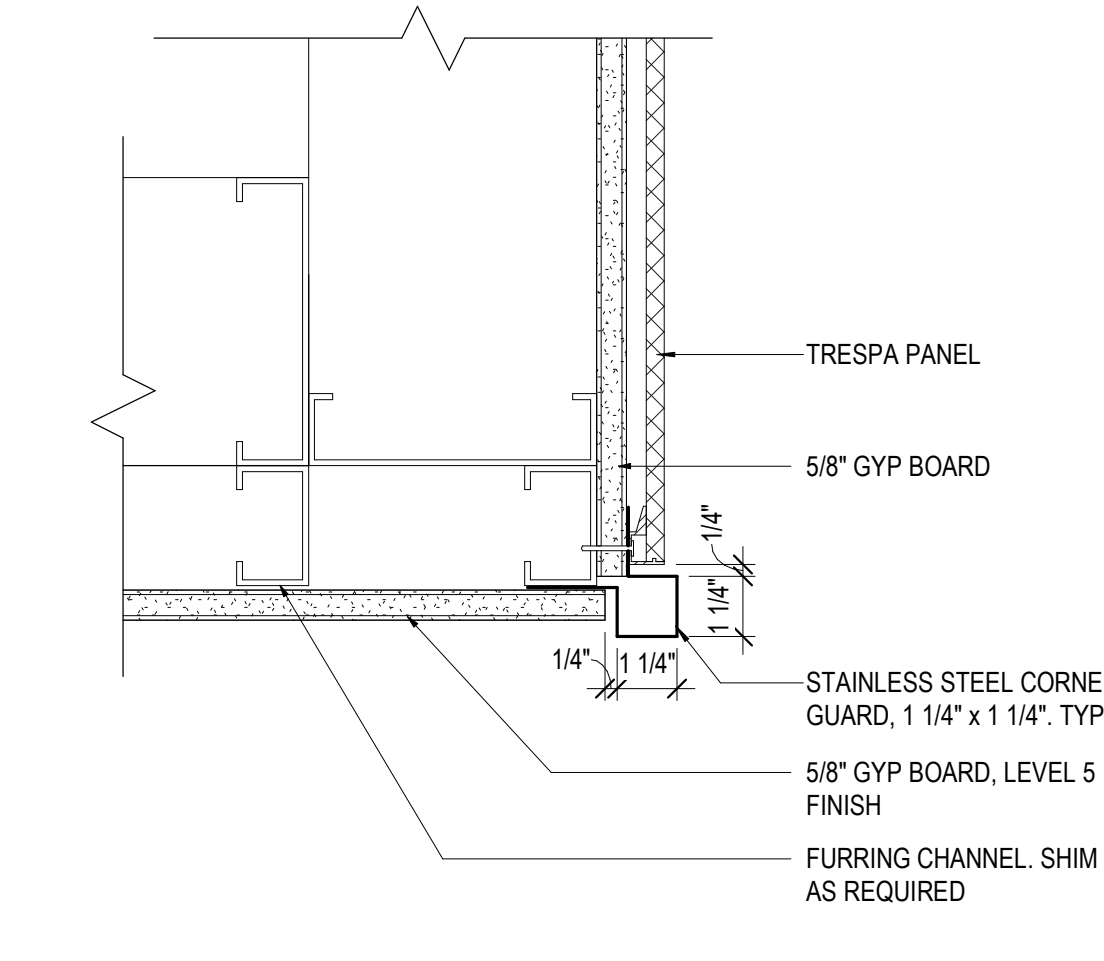


14 DETAIL - ART AT END CORNER - TONY BERLANT
SCALE: 3\"/>

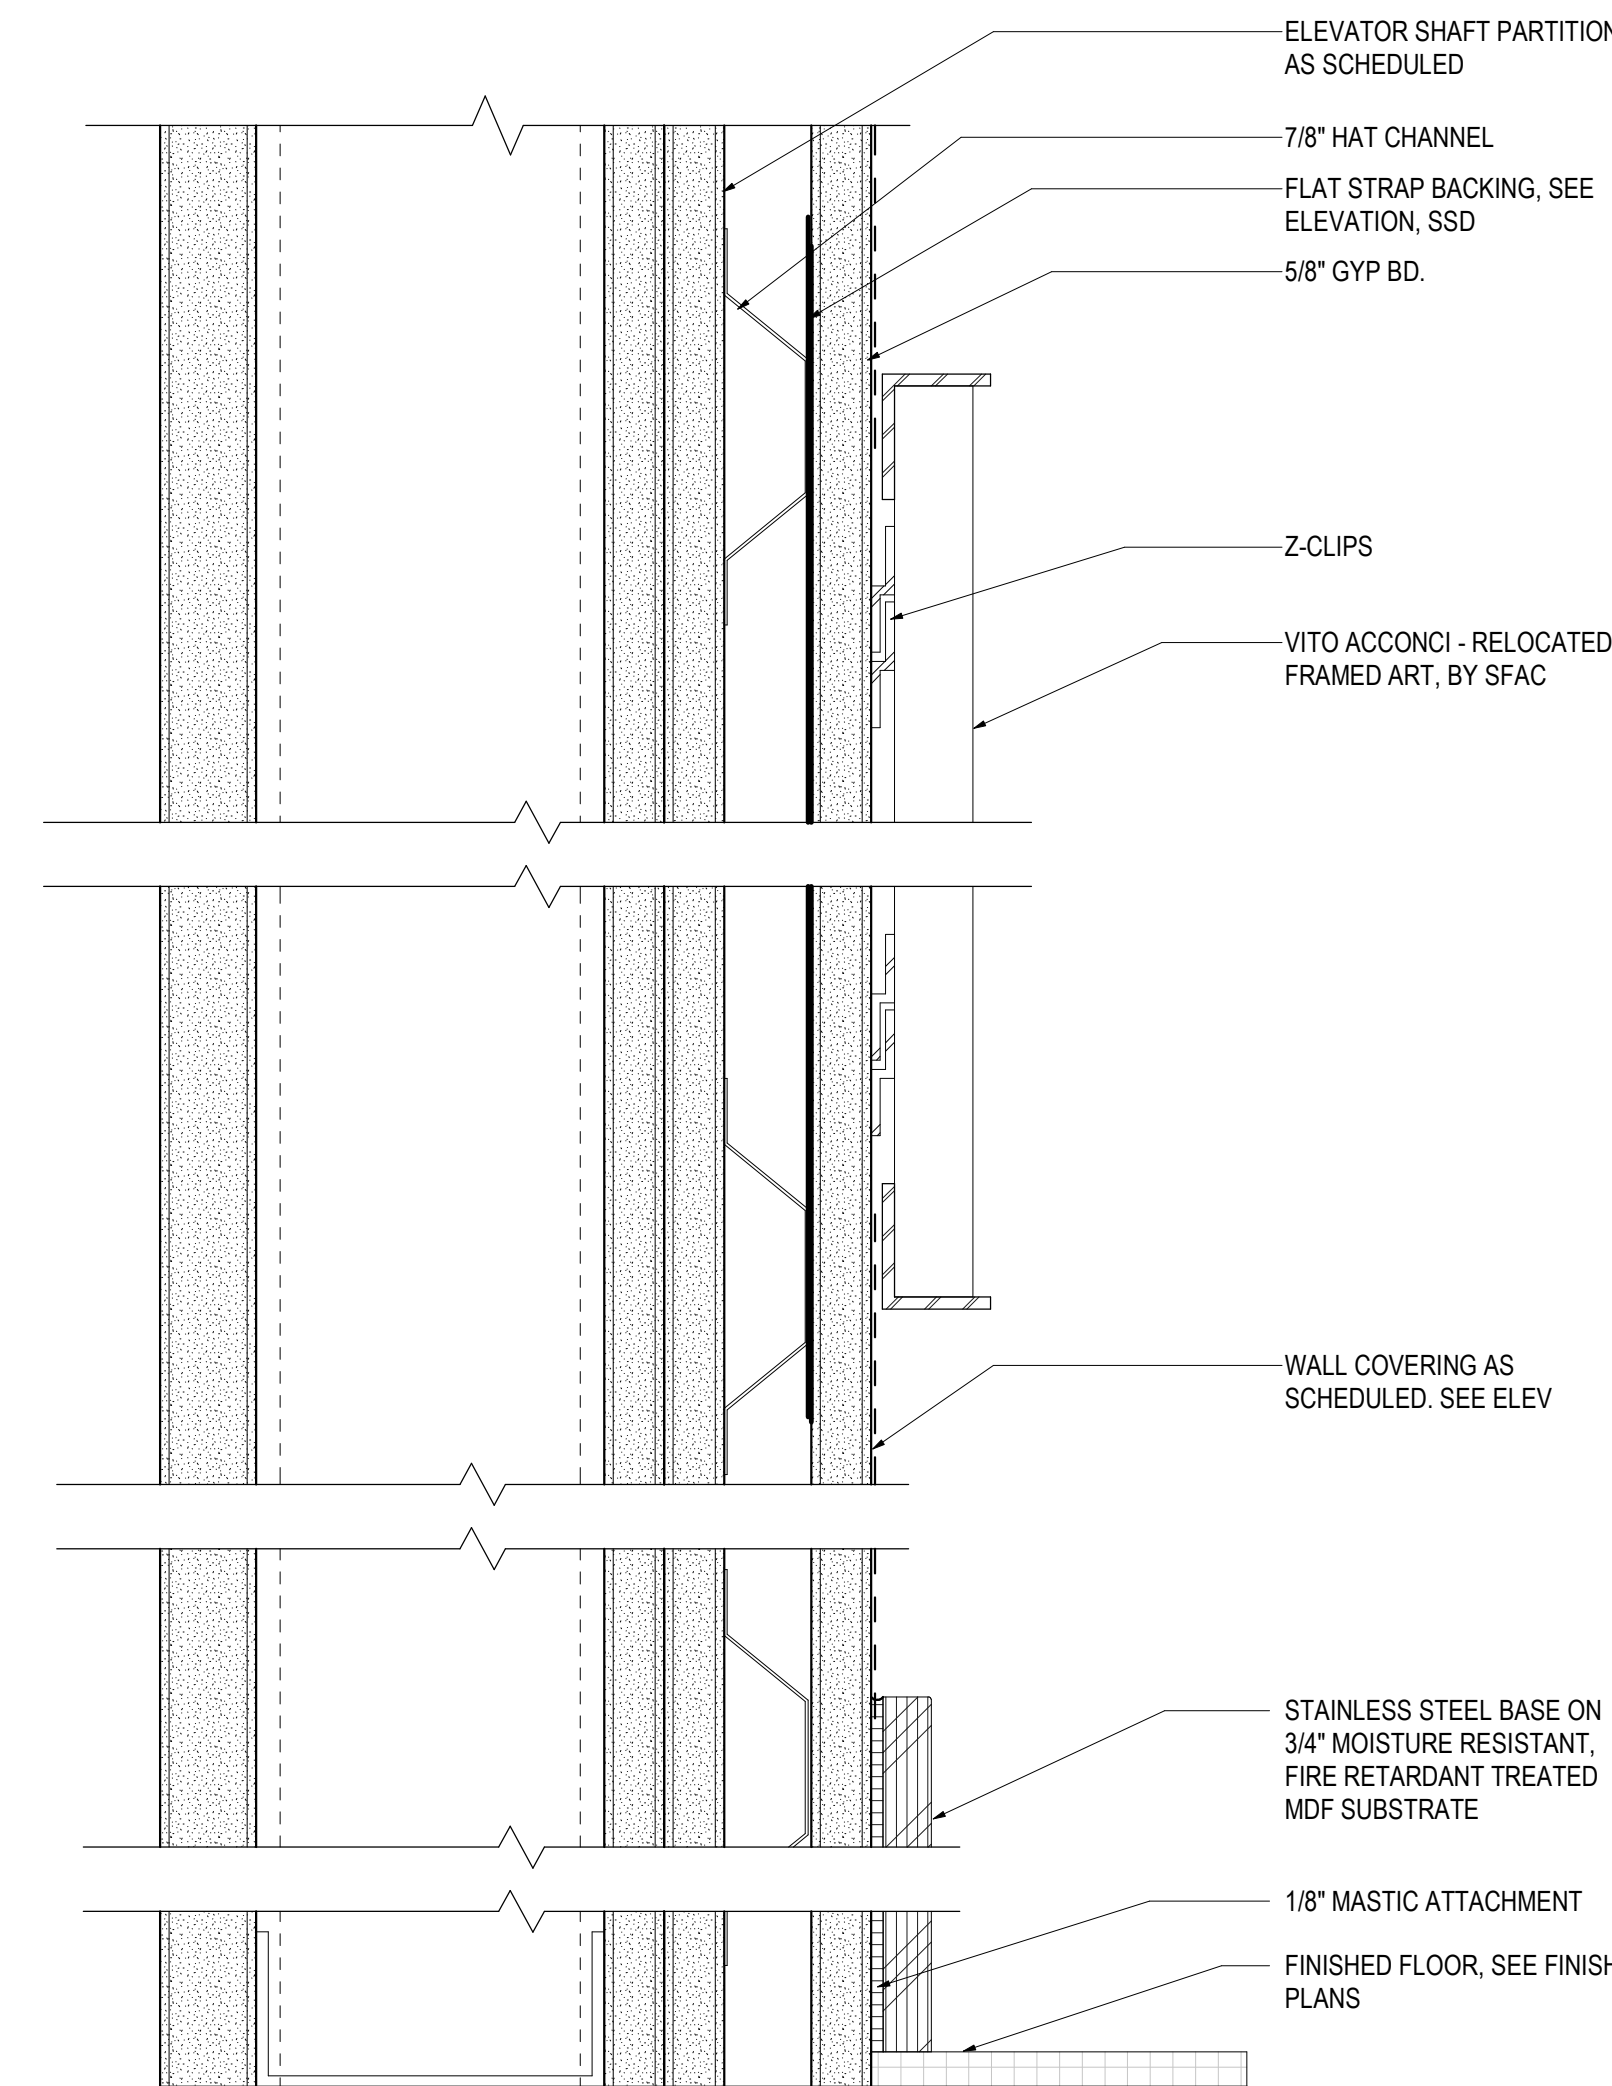


09 SECTION DETAIL - BASE AT ART NICHE
SCALE: 6\"/>

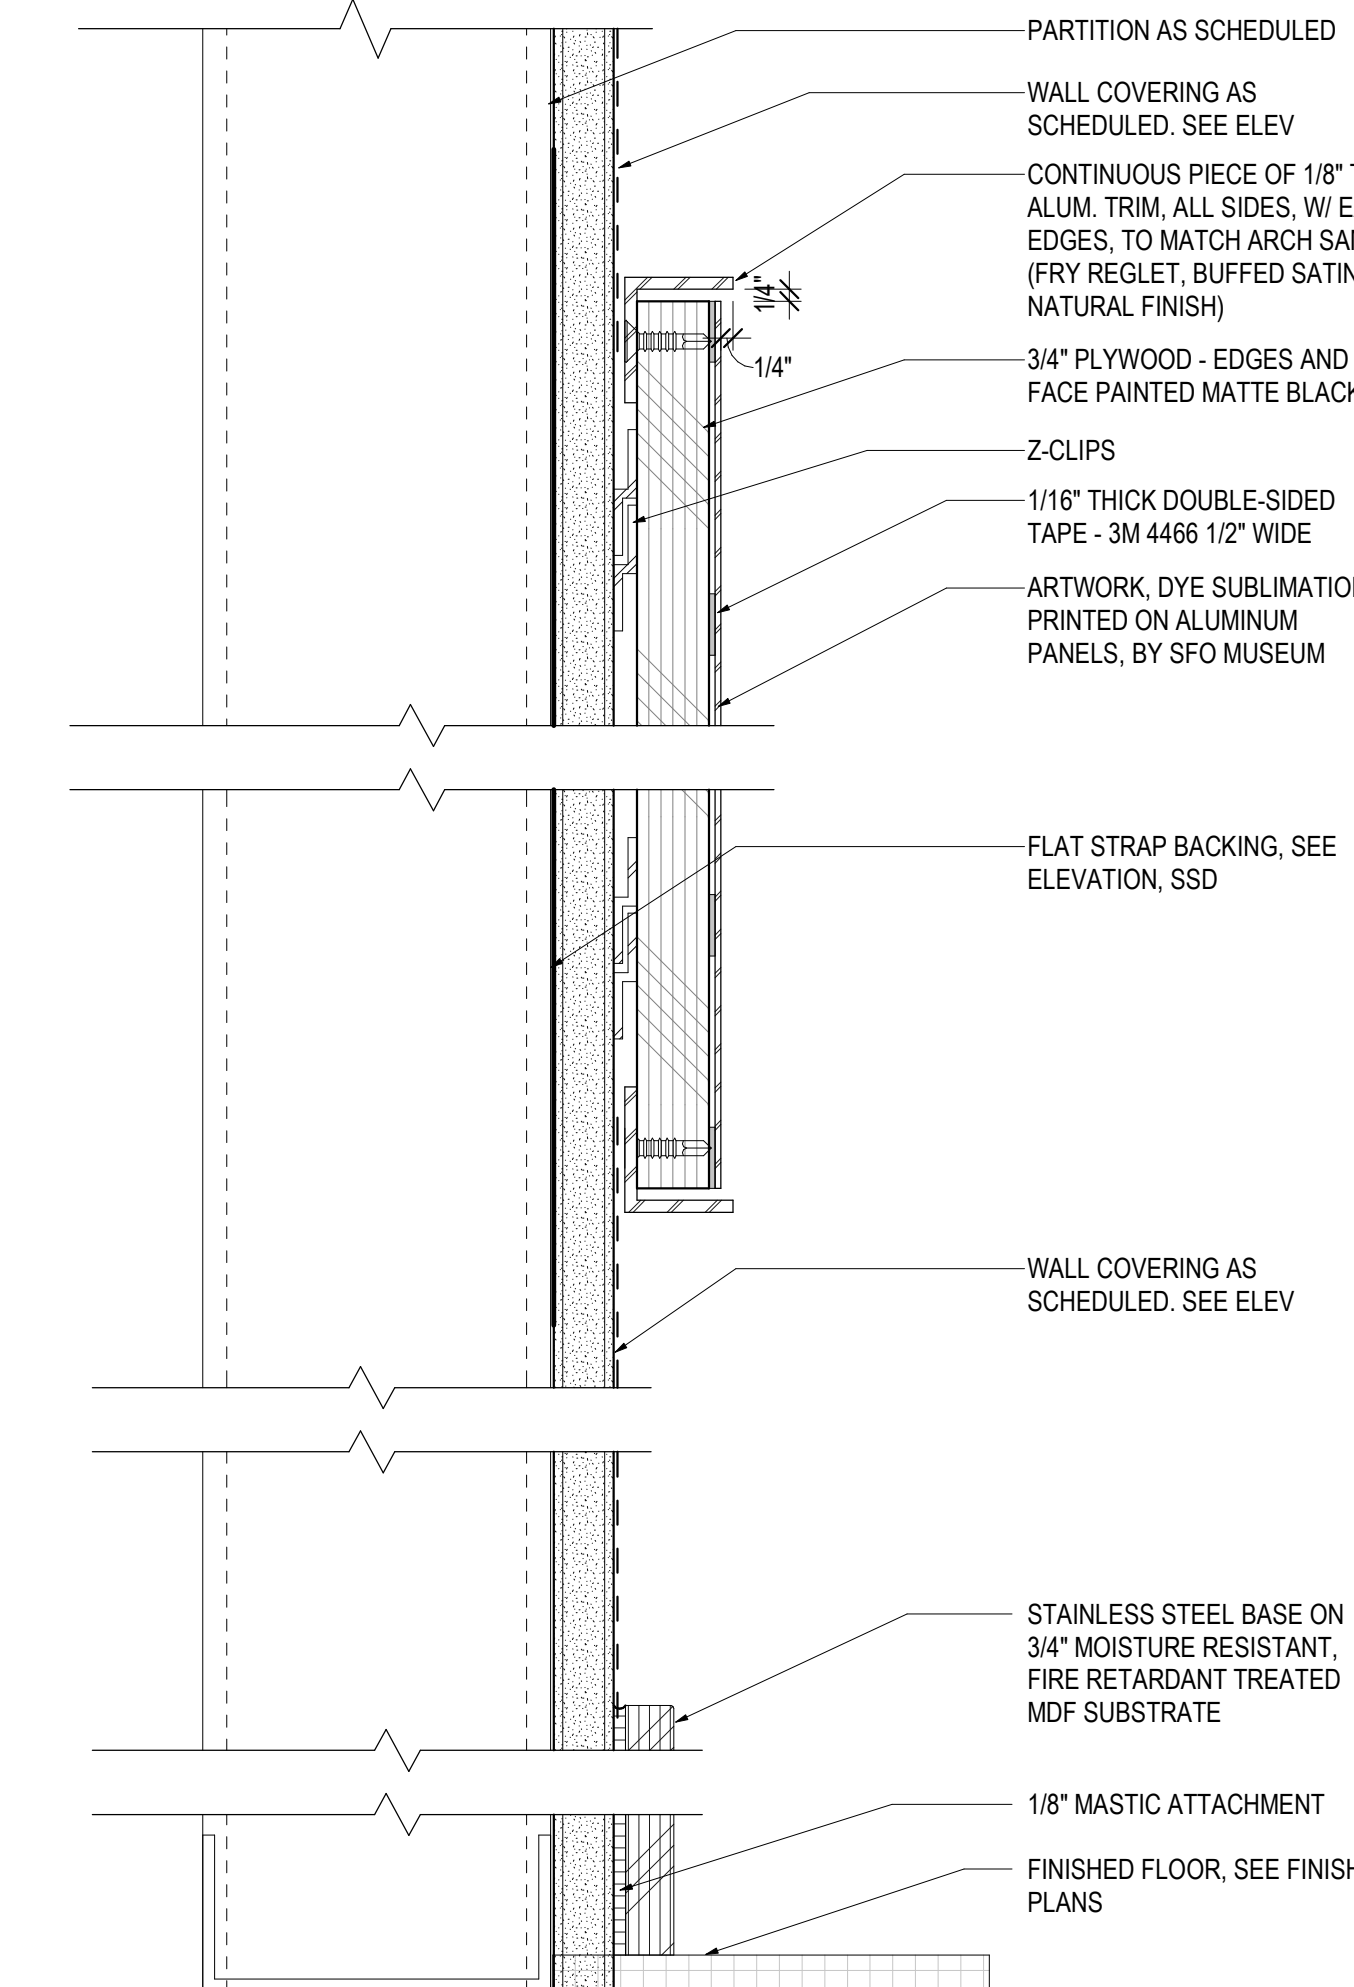


05 SECTION DETAIL - 2D ART PANEL AND FRAME
SCALE: 6\"/>

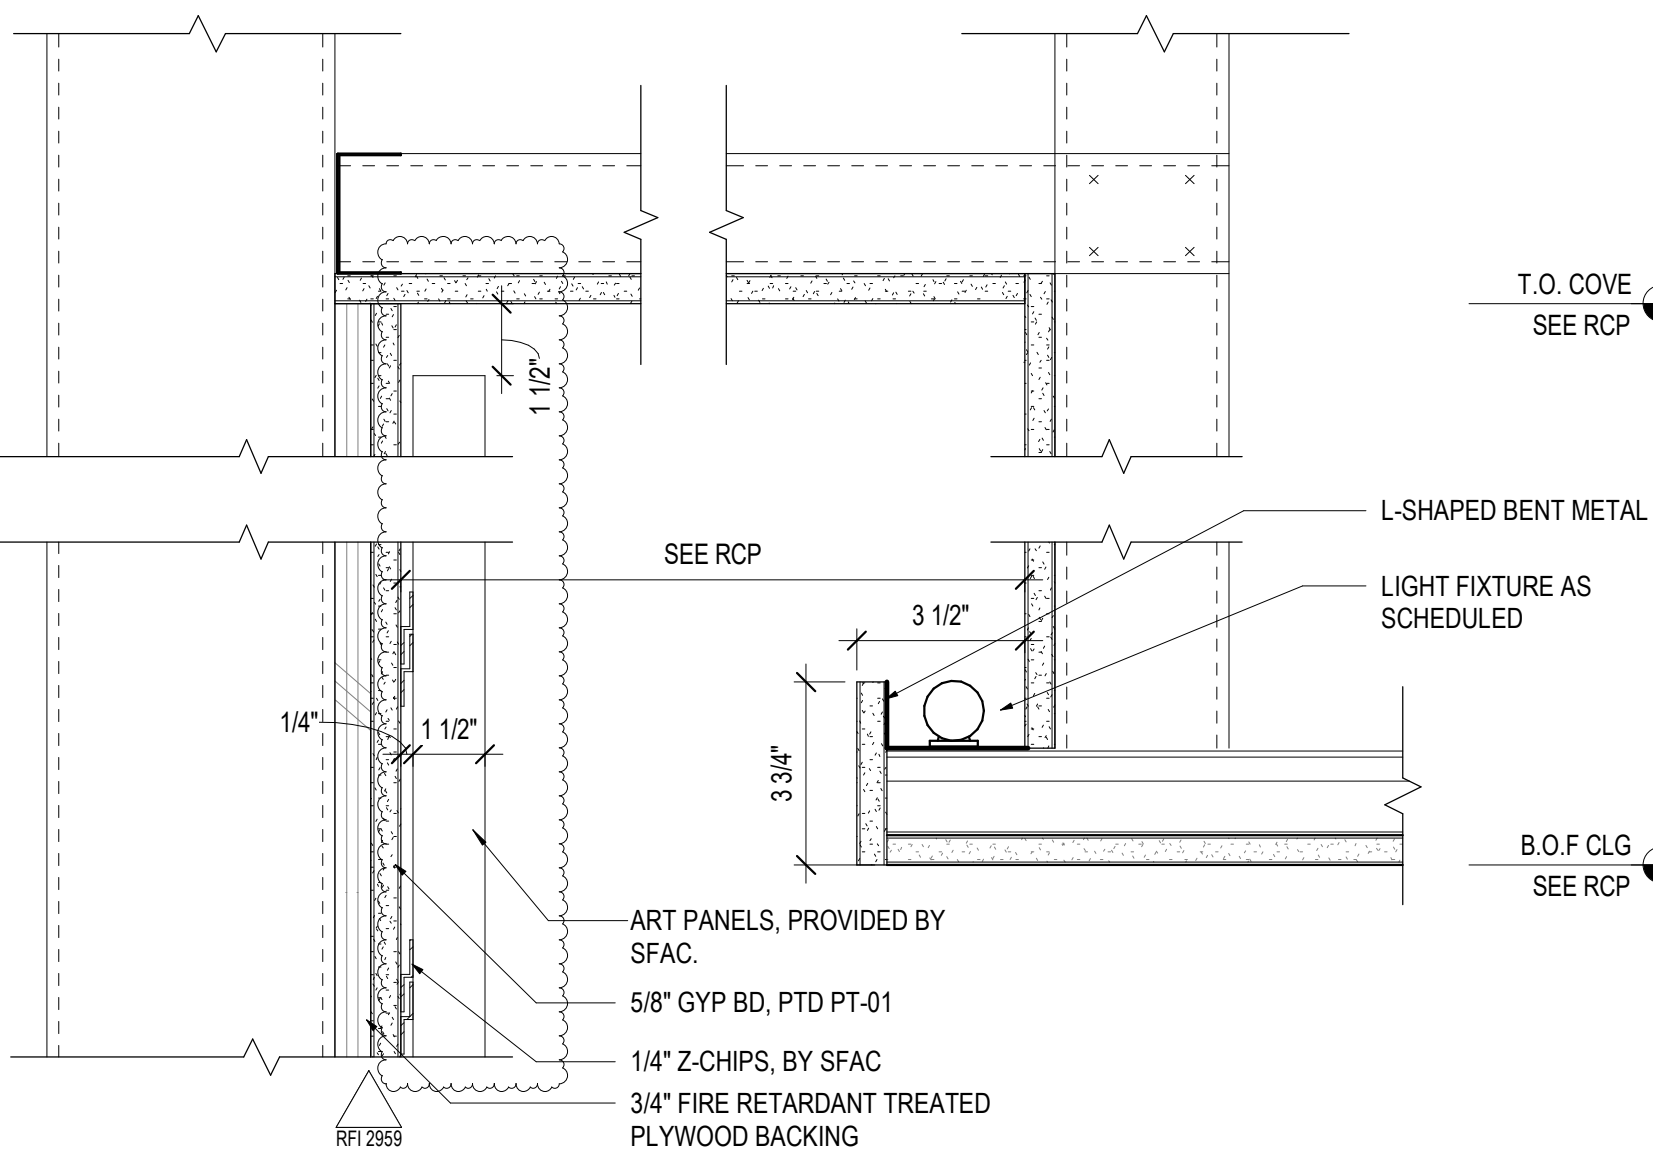

02 DETAIL - CLG LIGHT COVE AT TONY BERLANT ART LOCATION
SCALE: 3\"/>

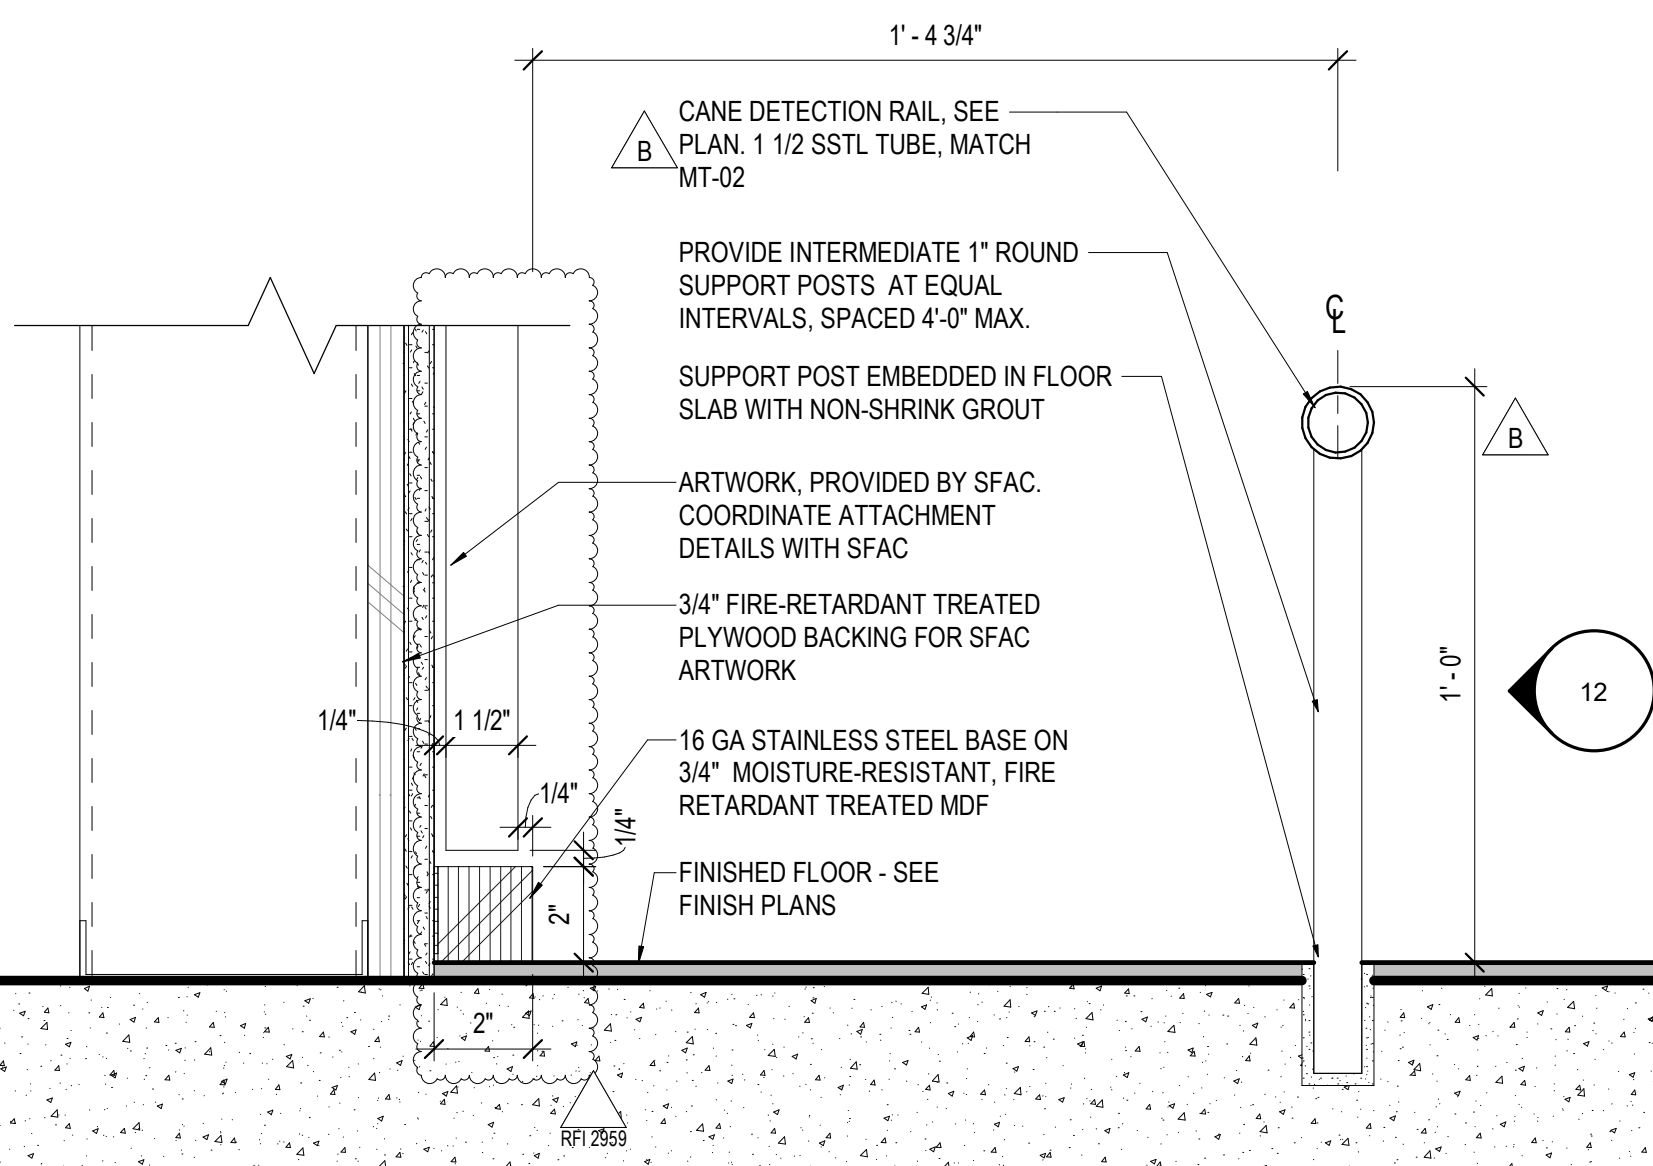


01 DETAIL - ART BASE AT TONY BERLANT ART LOCATION
SCALE: 3\"/>

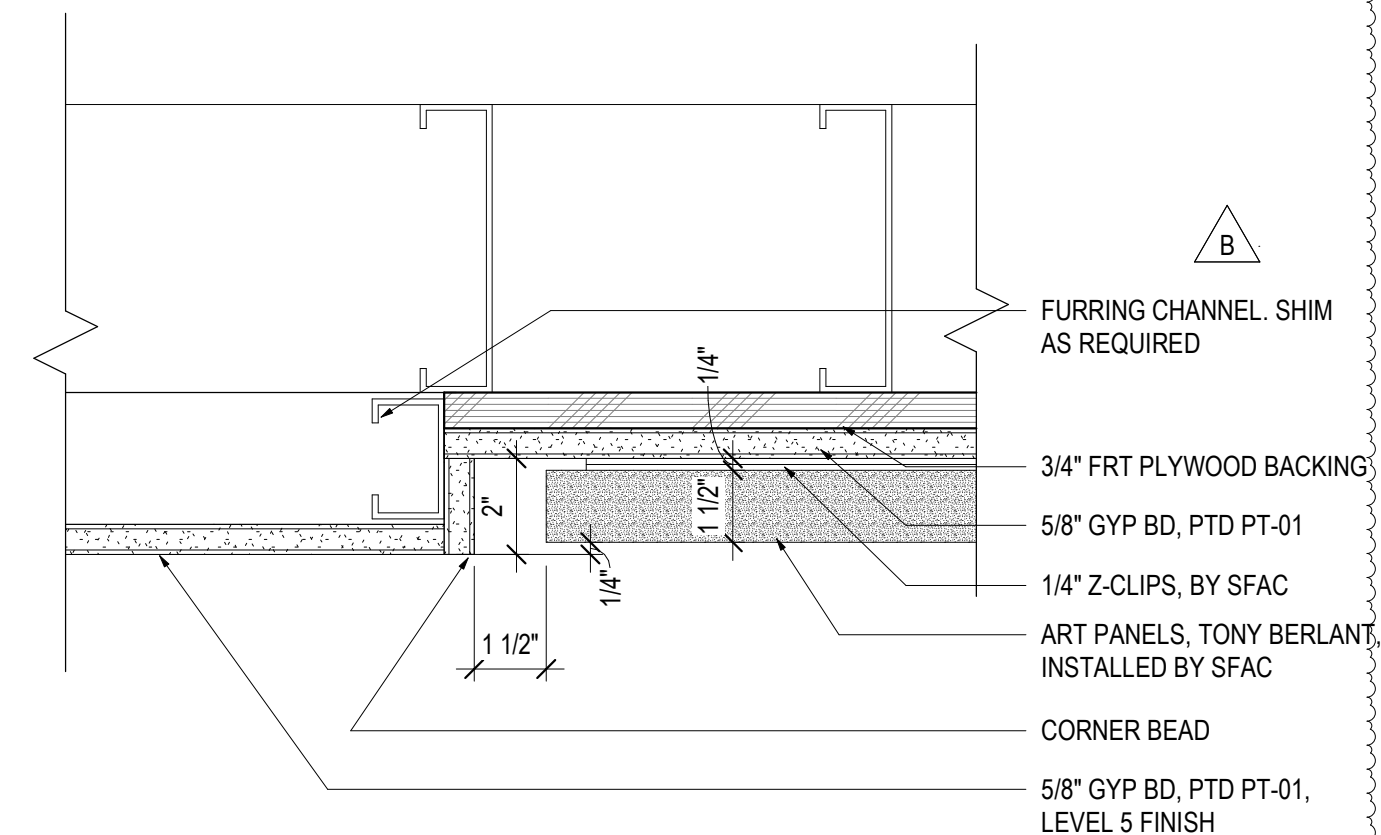

13 DETAIL - ART NICHE - TONY BERLANT
SCALE: 3\"/>



San Francisco International Airport

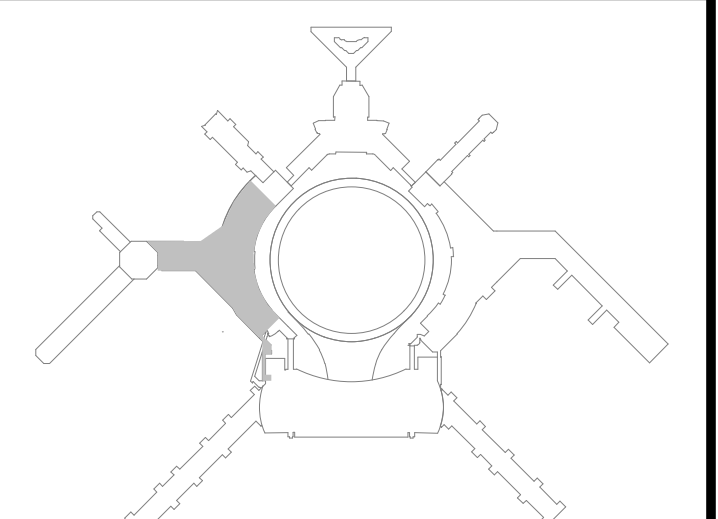

Key Map

REVISIONS	
NO.	DATE
1	08/29/2025
2	11/14/2025

ONGOING DESIGN CHANGES AND RFI'S TO BE CONFORMED TO THIS PACKAGE 6 - ISSUE FOR PERMIT

RFI 2569

RFI 2569



100 Pringle Ave, Suite 340
Walnut Creek, CA 94596
415-509-4229



220 Montgomery Street, Suite 200
San Francisco, CA 94104
415-433-3700



1420 Sutter Street
San Francisco, CA 94109
415-391-7918

CONTRACT NO.	PROJECT TITLE	SHEET TITLE	
10071.76_400	TERMINAL 3 WEST MODERNIZATION	PACKAGE 6 - VOL 3	ARTS ENRICHMENT DETAILS

APPROVED:

APPROVED:

DESIGNED BY:

DRAWN BY:

SCALE: As indicated

SHEET NUMBER

CHECKED BY:

DATE: 02/28/2026

SIZE: ARCH-E1

06-A9.06.41